

PROJECT TITLE: PROPOSE ELEMENTERY, JUNIOR & SENIOR HIGH SCHOOL
PROJECT LOCATION: BASSA TOWN, BUCHANAN CITY, GRAND BASSA COUNTY, LIBERIA
PROJECT OWNER: HELP LIBERIA FOUNDATION



DESIGNED & DRAWN BY: ALEXANDER P.B. YEAHER JR

3D VIEWS OF PROPOSE STRUCTURE





Ⓐ PROPOSE FRONT ELEVATION



**FUTURE BUILDERS &
DEVELOPMENT GROUP INC.**

MOTTO:
QUALITY WITH PASSION

CLIENT :
HELP LIBERIA FOUNDATION
LOCATION : BUCHANAN CITY, LIBERIA
PROJECT :
PROPOSE ELEMENTARY, JUNIOR & SENIOR HIGH SCHOOL


DRAWING TITLE :
PROPOSE FRONT ELEVATION

FUTURE BUILDER & DEVELOPMENT GROUP INC.		SIGN
DESIGNED BY :	Mr. Alexander P.B. Yeaher Jr.	
DRAWING NO.	DATE	SCALE
A-201	OCTOBER 2020	1/8" = 1'-0"

Contact #; +231886232714/+231777544642

Email: fbdgincorporated@gmail.com

COPYRIGHT RESERVED
THIS DESIGN AND DETAIL ARE, AND
AT ALL TIMES THE EXCLUSIVE
PROPERTY OF HELP LIBERIA FOUNDATION
AND CAN NOT BE USED OR REPRODUCED
WITHOUT WRITTEN CONSENT.

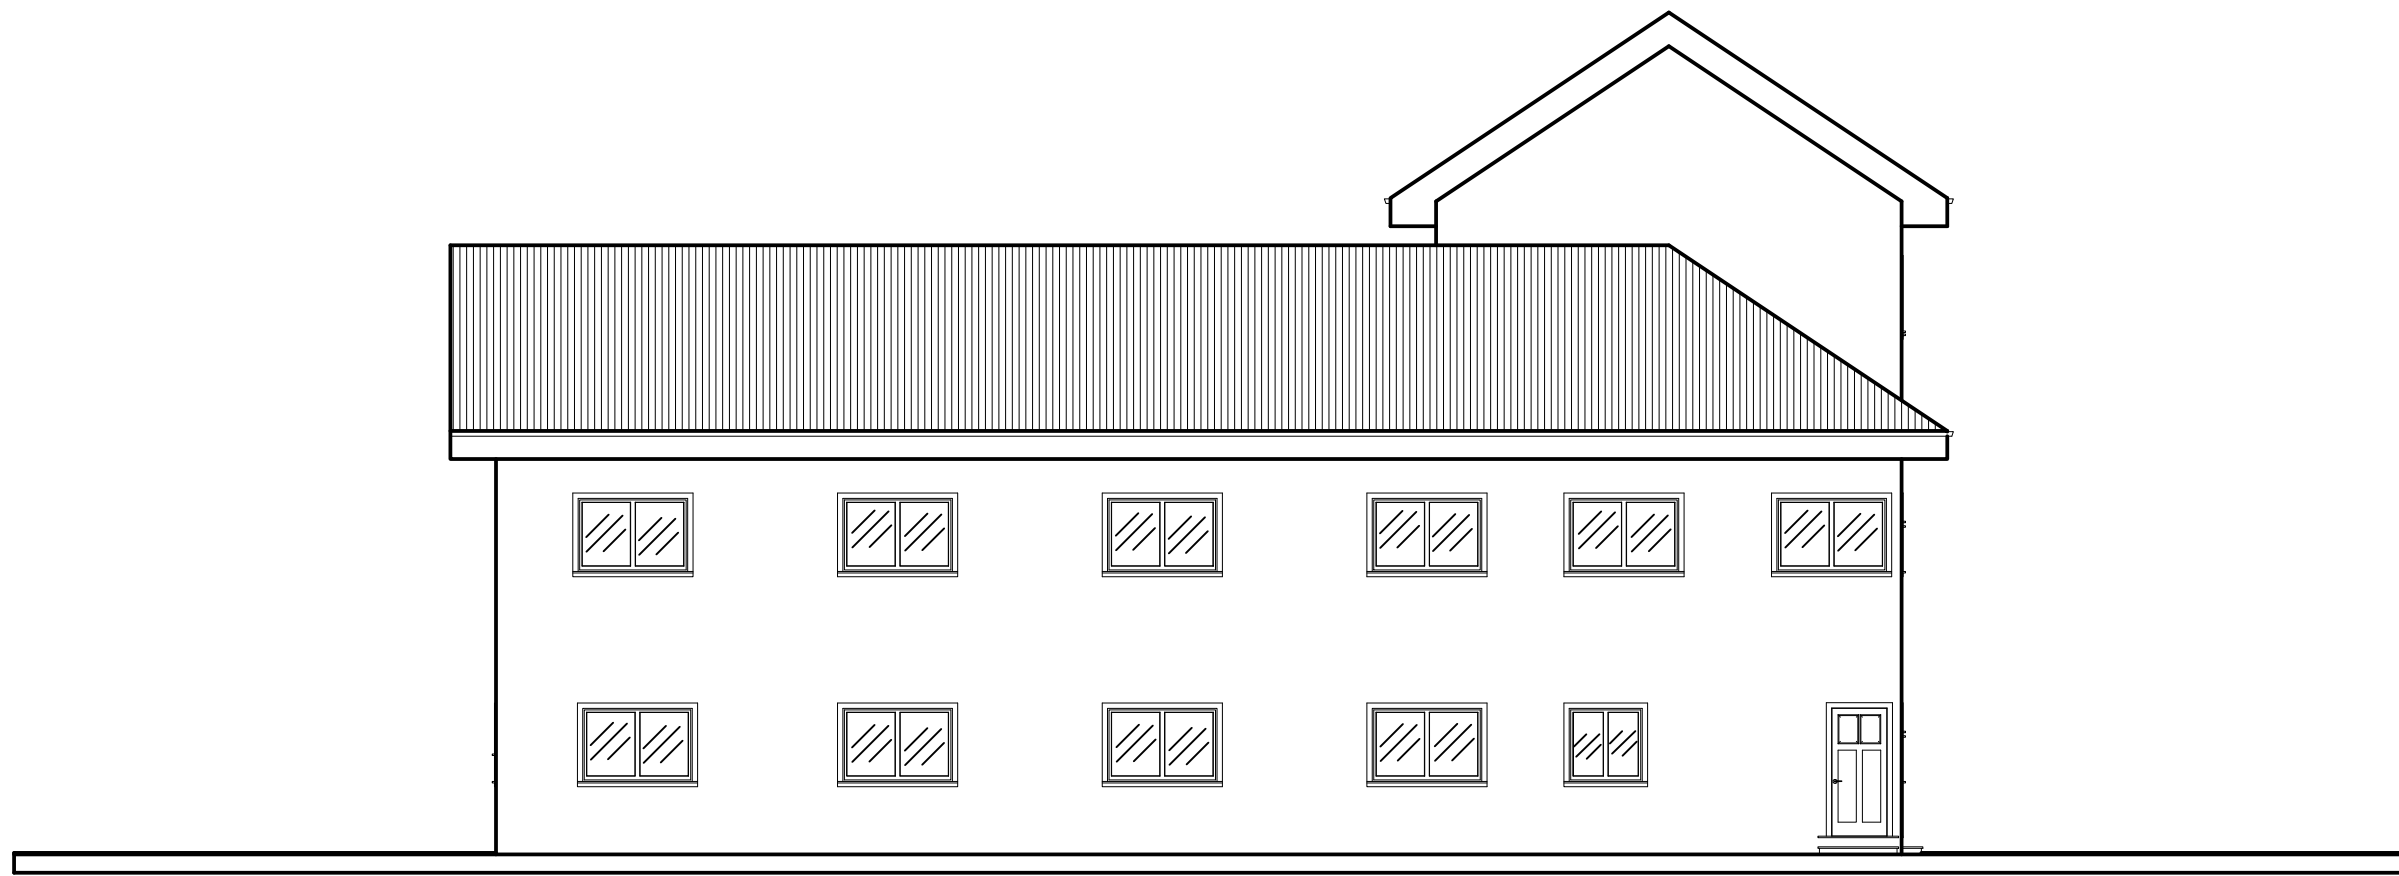

Ⓐ PROPOSE BACK ELEVATION



MOTTO:
QUALITY WITH PASSION

CLIENT :
HELP LIBERIA FOUNDATION

LOCATION : BUCHANAN CITY, LIBERIA

PROJECT :
PROPOSE ELEMENTARY, JUNIOR & SENIOR HIGH SCHOOL


DRAWING TITLE :
PROPOSE BACK ELEVATION

FUTURE BUILDER & DEVELOPMENT GROUP INC.		SIGN
DESIGNED BY :	Mr. Alexander P.B. Yeaher Jr.	
DRAWING NO.	DATE	SCALE
A-202	OCTOBER 2020	1/8" = 1'-0"

Contact #; +231886232714/+231777544642

Email: fbdgincorporated@gmail.com

COPYRIGHT RESERVED
THIS DESIGN AND DETAIL ARE, AND
AT ALL TIMES THE EXCLUSIVE
PROPERTY OF HELP LIBERIA FOUNDATION
AND CAN NOT BE USED OR REPRODUCED
WITHOUT WRITTEN CONSENT.

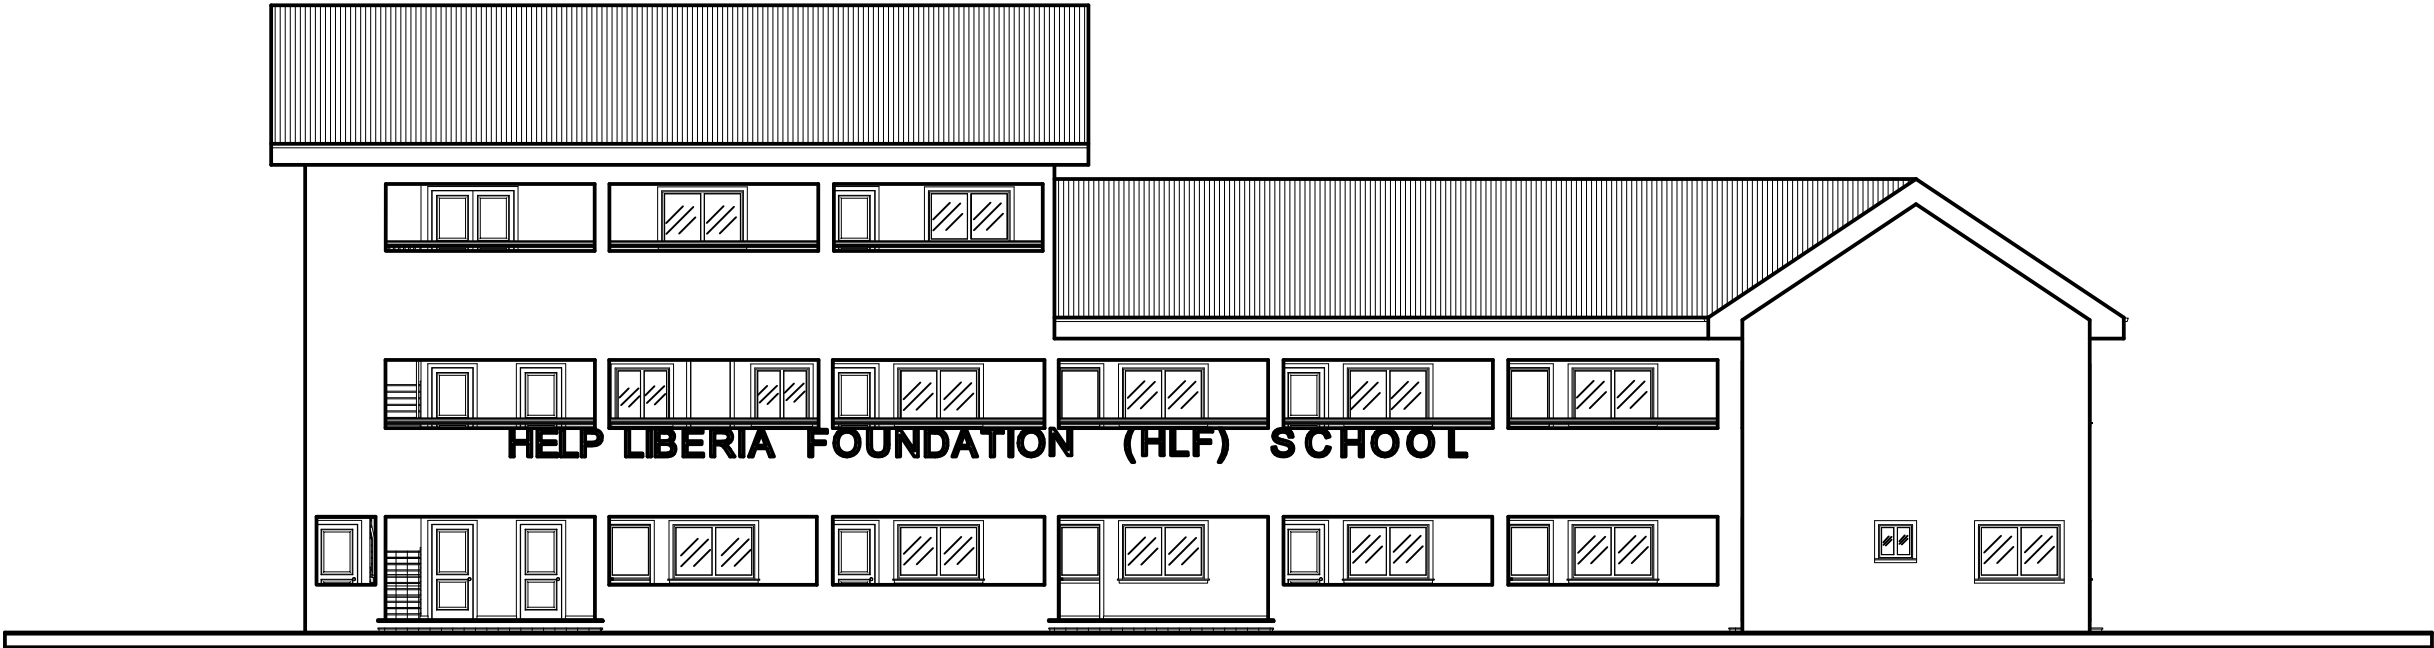

A PROPOSE RIGHT SIDE ELEVATION



**FUTURE BUILDERS &
DEVELOPMENT GROUP INC.**

MOTTO:
QUALITY WITH PASSION

CLIENT :
HELP LIBERIA FOUNDATION


LOCATION : BUCHANAN CITY, LIBERIA

PROJECT :
PROPOSE ELEMENTARY, JUNIOR & SENIOR HIGH SCHOOL

DRAWING TITLE :
PROPOSE RIGHT SIDE ELEVATION

FUTURE BUILDER & DEVELOPMENT GROUP INC.		SIGN
DESIGNED BY :	Mr. Alexander P.B. Yeaher Jr.	
DRAWING NO.	DATE	SCALE
A-203	OCTOBER 2020	1/8" = 1'-0"
Contact #; +231886232714/+231777544642		
Email: fbdgincorporated@gmail.com		

COPYRIGHT RESERVED
THIS DESIGN AND DETAIL ARE, AND
AT ALL TIMES THE EXCLUSIVE
PROPERTY OF HELP LIBERIA FOUNDATION
AND CAN NOT BE USED OR REPRODUCED
WITHOUT WRITTEN CONSENT.

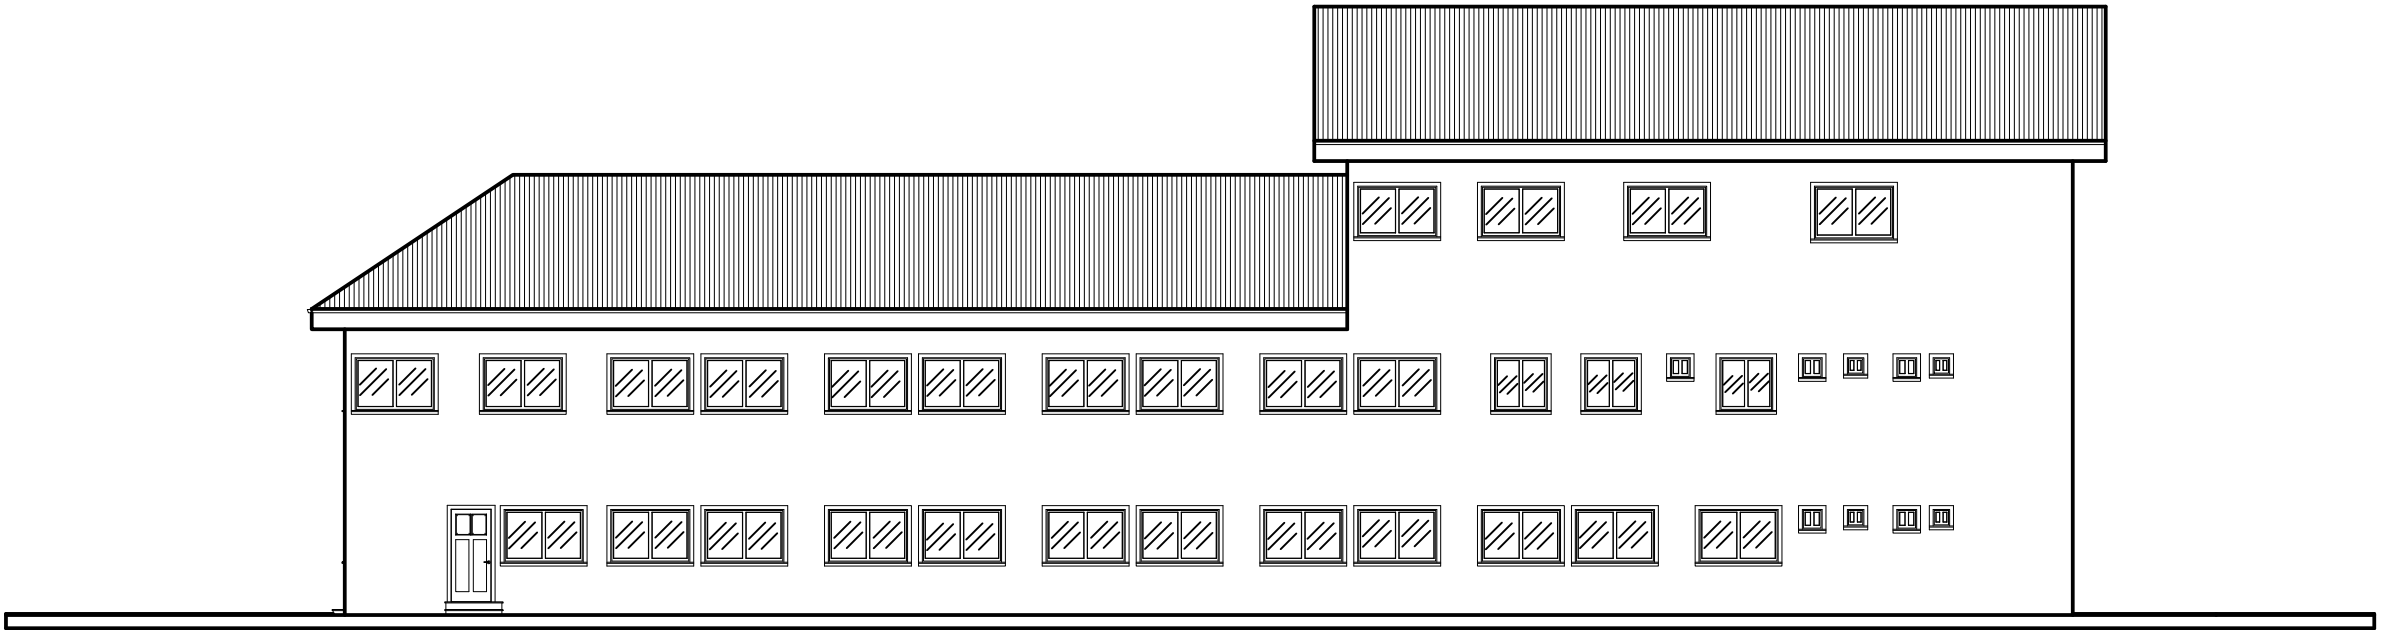

A PROPOSE LEFT SIDE ELEVATION

F+BDG

FUTURE BUILDERS & DEVELOPMENT GROUP INC.

MOTTO:
QUALITY WITH PASSION

CLIENT :
HELP LIBERIA FOUNDATION


LOCATION : TRUCHANAN CITY, LIBERIA

PROJECT :
PROPOSE ELEMENTARY, JUNIOR & SENIOR HIGH SCHOOL

DRAWING TITLE :
PROPOSE LEFT SIDE ELEVATION

FUTURE BUILDER & DEVELOPMENT GROUP INC.		SIGN
DESIGNED BY :	Mr. Alexander P.B. Yeaher Jr.	
DRAWING NO.	DATE	SCALE
A-204	OCTOBER 2020	1/8" = 1'-0"
Contact #: +231886232714/+231777544642		
Email: fbdgincorporated@gmail.com		

COPYRIGHT RESERVED
THIS DESIGN AND DETAIL ARE, AND
AT ALL TIMES THE EXCLUSIVE
PROPERTY OF HELP LIBERIA FOUNDATION
AND CAN NOT BE USED OR REPRODUCED
WITHOUT WRITTEN CONSENT.

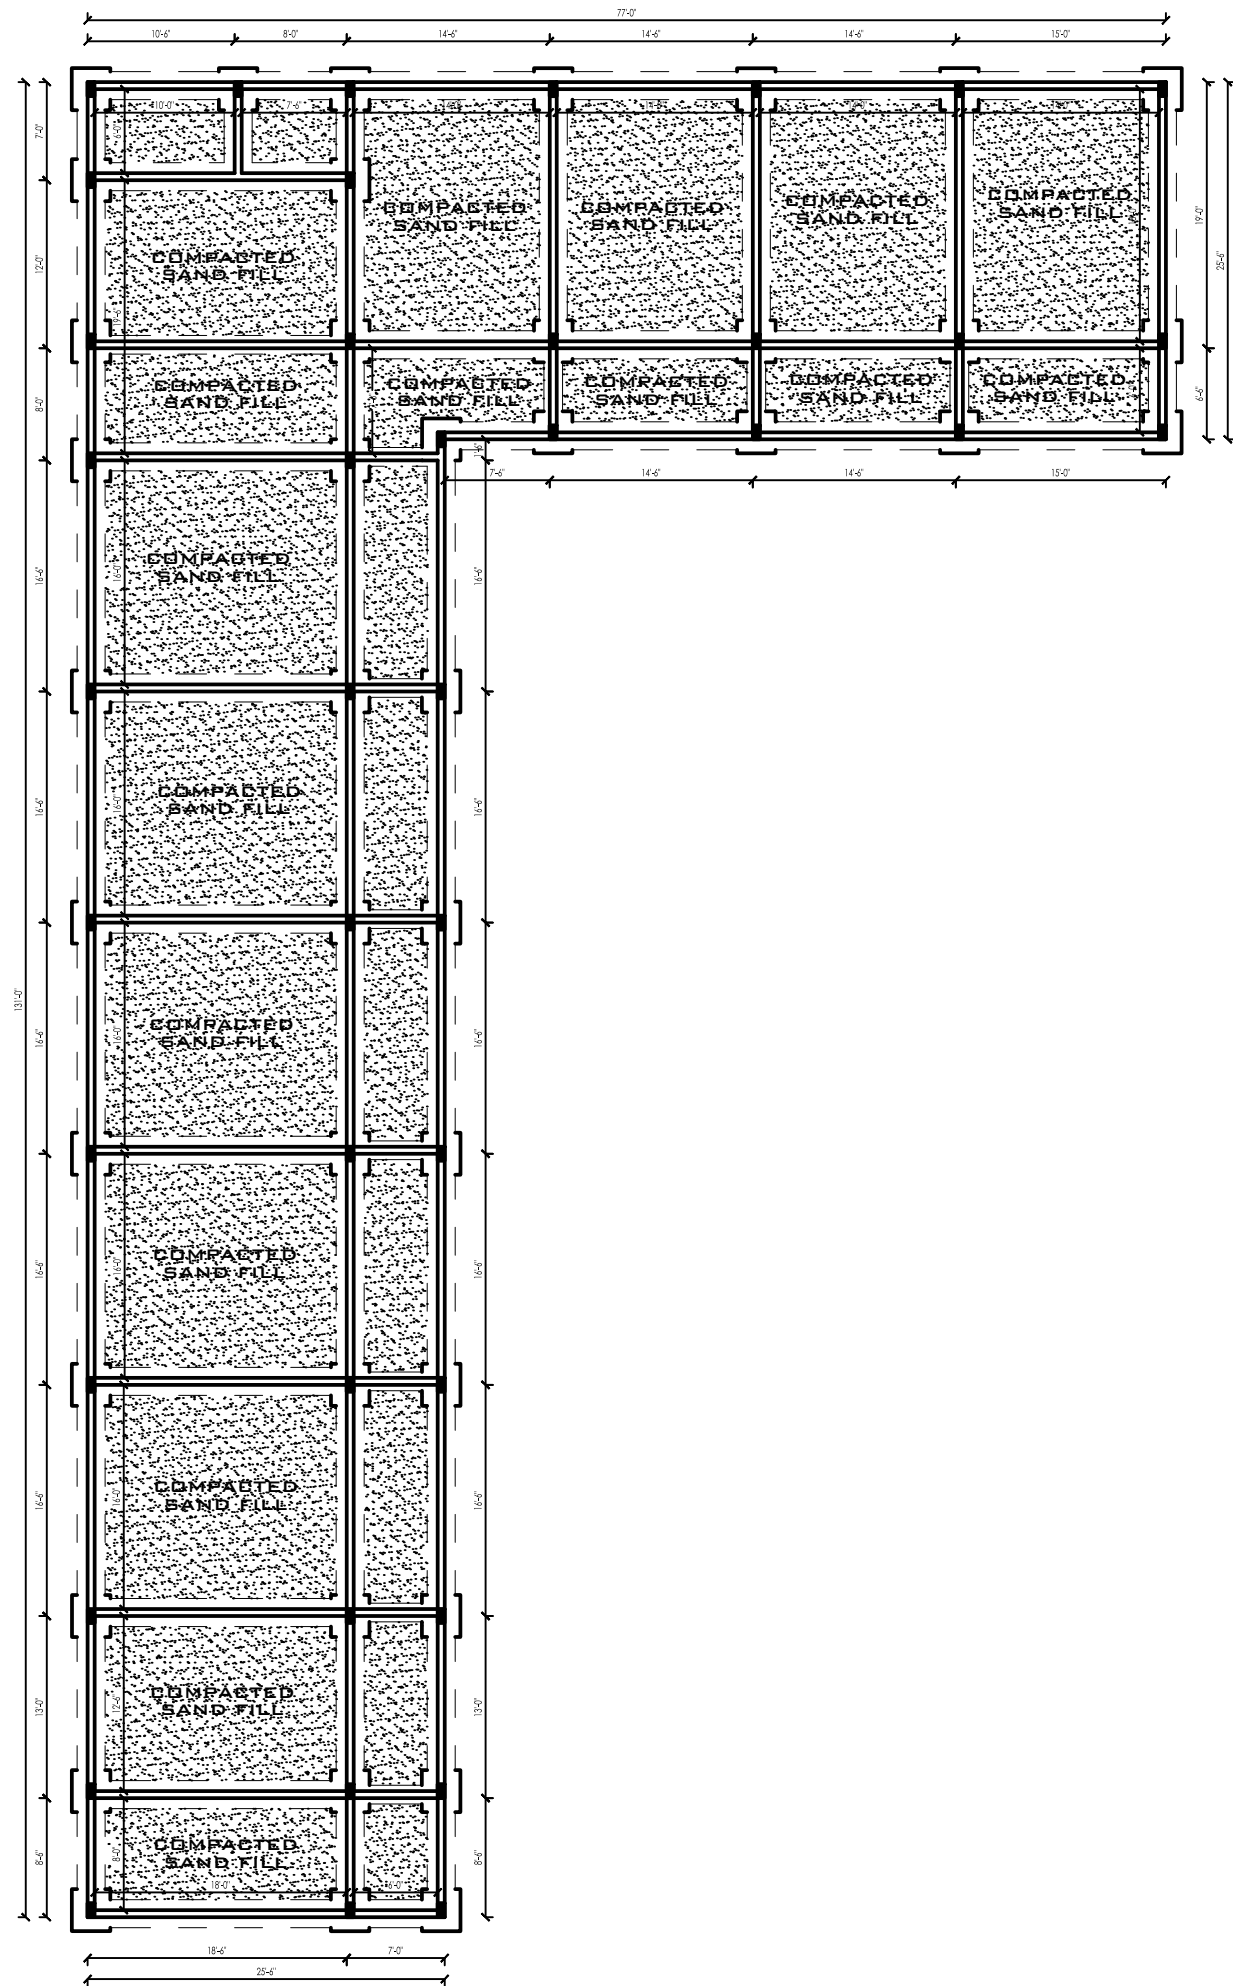

PROPOSE FOUNDATION PLAN
LIVING AREA
4653 sq ft



MOTTO:
QUALITY WITH PASSION

CLIENT :

HELP LIBERIA FOUNDATION

LOCATION : BUCHANAN CITY, LIBERIA

PROJECT :



PROPOSE ELEMENTARY, JUNIOR & SENIOR HIGH SCHOOL

DRAWING TITLE :

PROPOSE FOUNDATION PLAN

FUTURE BUILDER & DEVELOPMENT GROUP INC.		SIGN
DESIGNED BY :	Mr. Alexander P.B. Yeather Jr.	
DRAWING NO.	DATE	SCALE
A-205	OCTOBER 2020	1/8" = 1'-0"
Contact # : +231886232714/+231777544642		
Email : fbdgincorporated@gmail.com		

COPYRIGHT RESERVED
THIS DESIGN AND DETAIL ARE, AND
AT ALL TIMES THE EXCLUSIVE
PROPERTY OF HELP LIBERIA FOUNDATION
AND CAN NOT BE USED OR REPRODUCED
WITHOUT WRITTEN CONSENT.

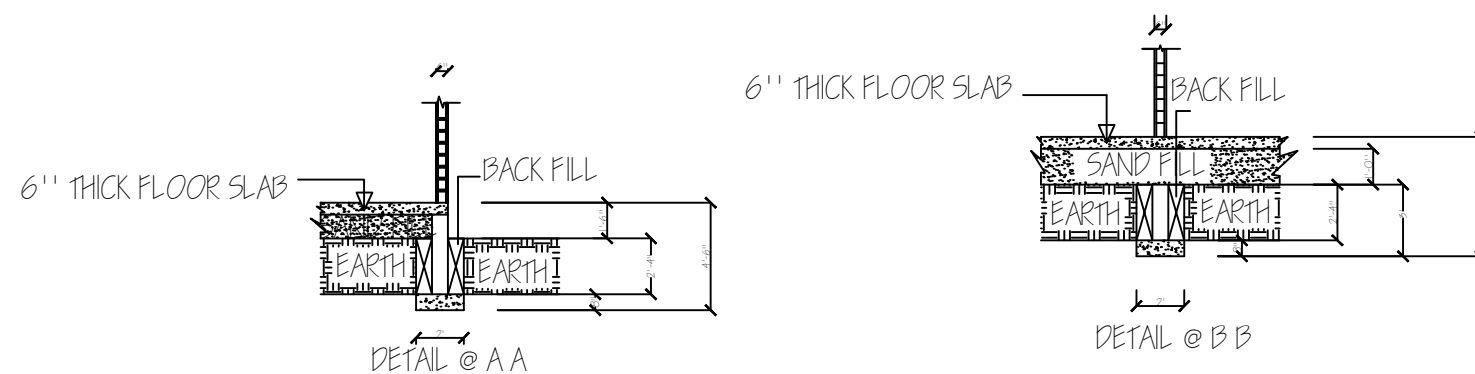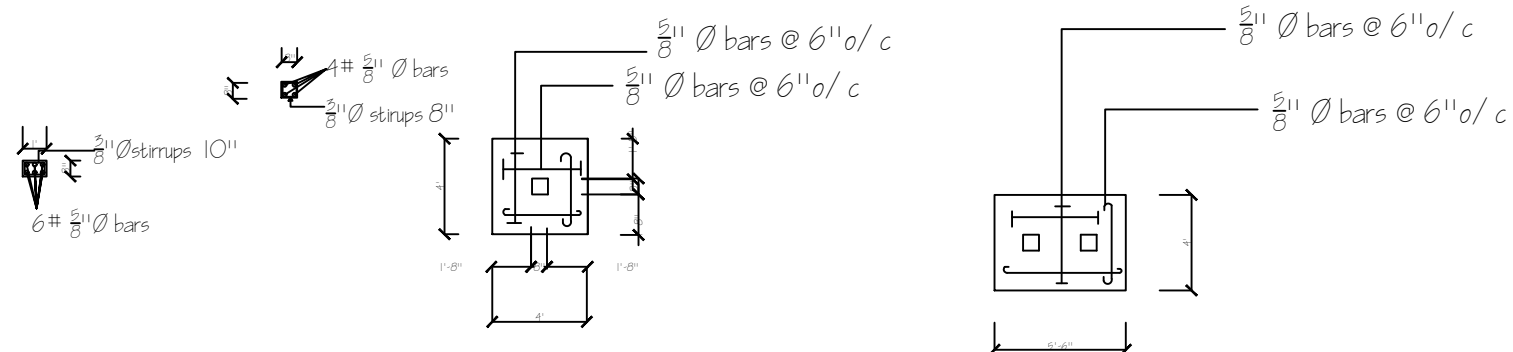

A COLUMN BASE/FOUNDATION DETAILS



**FUTURE BUILDERS &
DEVELOPMENT GROUP INC.**

MOTTO:
QUALITY WITH PASSION

CLIENT :

HELP LIBERIA FOUNDATION

LOCATION : **BUCHANAN CITY, LIBERIA**

PROJECT :

PROPOSE ELEMENTARY, JUNIOR & SENIOR HIGH SCHOOL

DRAWING TITLE :

COLUMN BASE/FOUNDATION DETAILS

FUTURE BUILDER & DEVELOPMENT GROUP INC.

SIGN

DESIGNED BY :

Mr. Alexander P.B. Yeaher Jr.

DRAWING NO.

DATE

SCALE

A-206






OCTOBER 2020

1/8" = 1'-0"

Contact #; +231886232714/+231777544642

Email: fbdgincorporated@gmail.com

COPYRIGHT RESERVED
THIS DESIGN AND DETAIL ARE, AND
AT ALL TIMES THE EXCLUSIVE
PROPERTY OF HELP LIBERIA FOUNDATION
AND CAN NOT BE USED OR REPRODUCED
WITHOUT WRITTEN CONSENT.

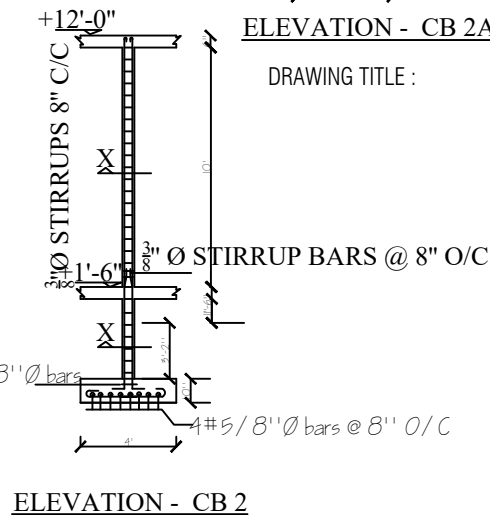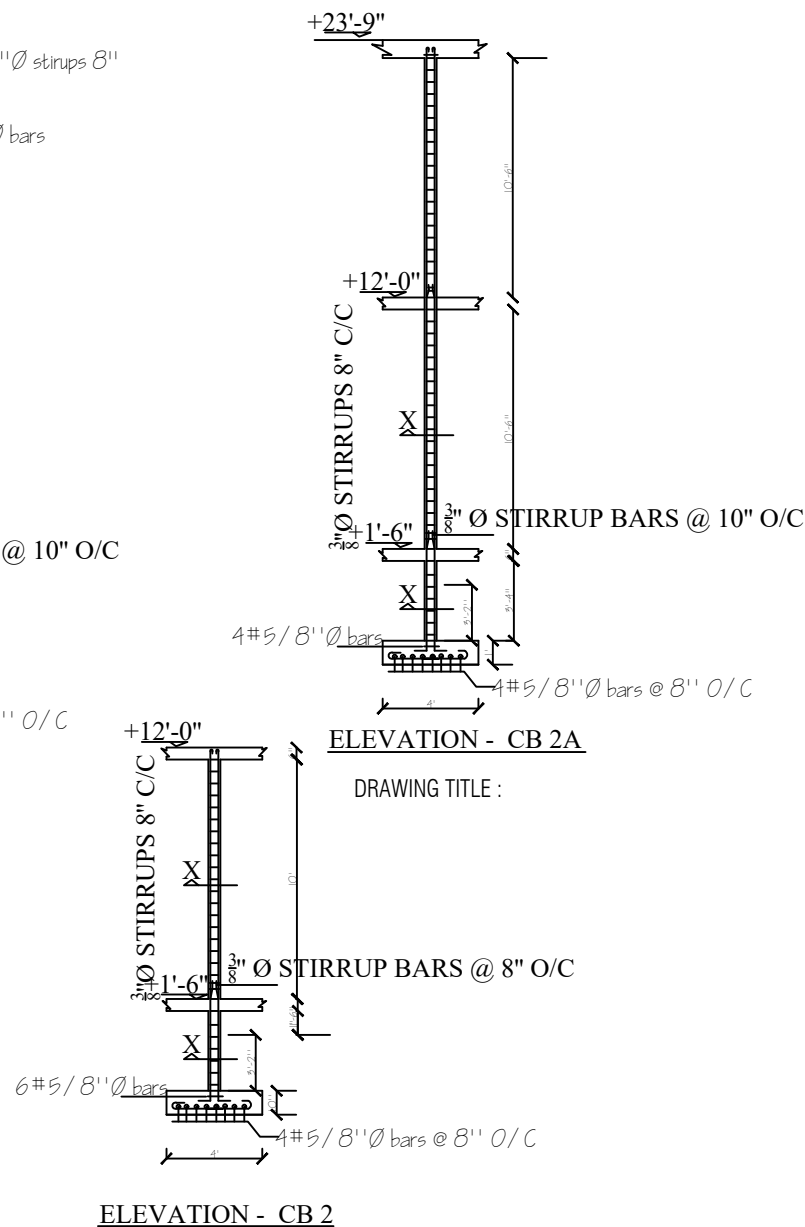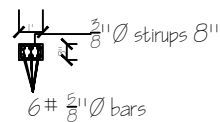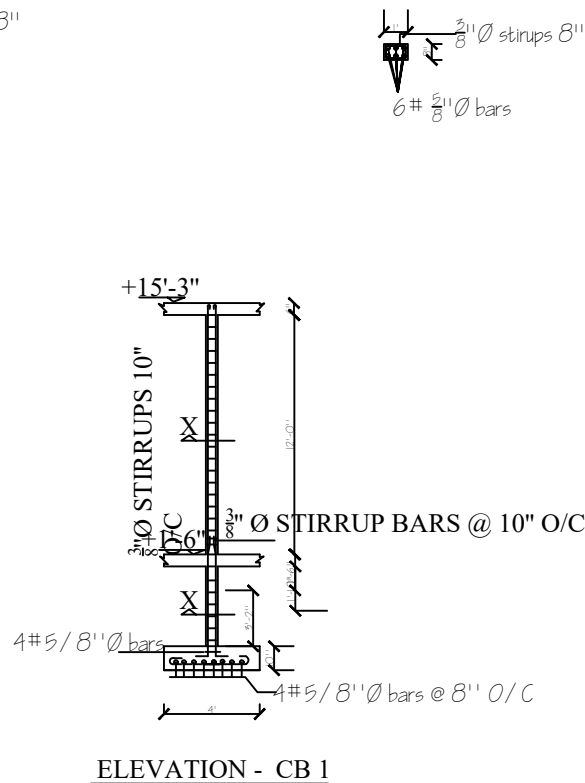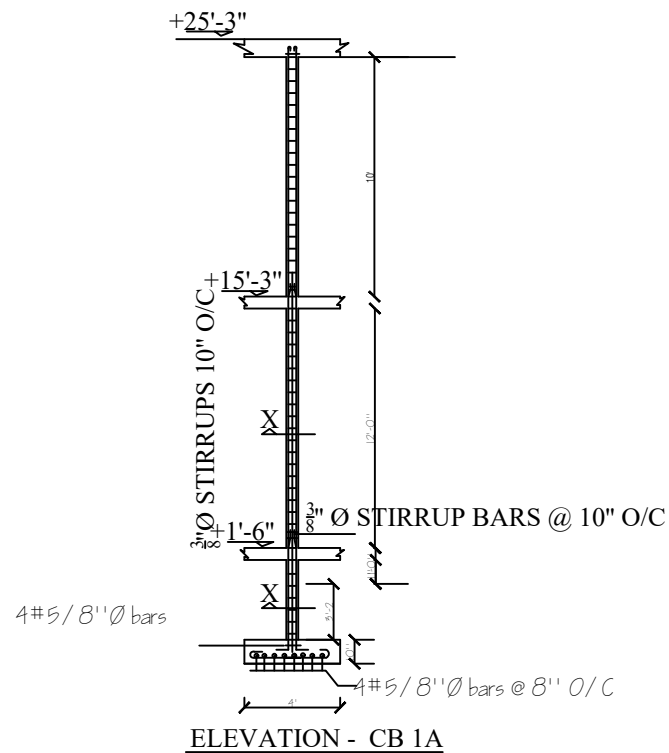

A COLUMNS ELEVATIONS



MOTTO:
QUALITY WITH PASSION

CLIENT :	HELP LIBERIA FOUNDATION
LOCATION :	BUCHANAN CITY, LIBERIA
PROJECT :	PROPOSE ELEMENTARY, JUNIOR & SENIOR HIGH SCHOOL


DRAWING TITLE :	COLUMN ELEVATIONS
-----------------	-------------------

FUTURE BUILDER & DEVELOPMENT GROUP INC.		SIGN
DESIGNED BY :	Mr. Alexander P.B. Yeaher Jr.	
DRAWING NO.	DATE	SCALE
A-207	OCTOBER 2020	1/8" = 1'-0"

Contact #; +231886232714/+231777544642

Email: fbdgincorporated@gmail.com

COPYRIGHT RESERVED
THIS DESIGN AND DETAIL ARE, AND
AT ALL TIMES THE EXCLUSIVE
PROPERTY OF HELP LIBERIA FOUNDATION
AND CAN NOT BE USED OR REPRODUCED
WITHOUT WRITTEN CONSENT.

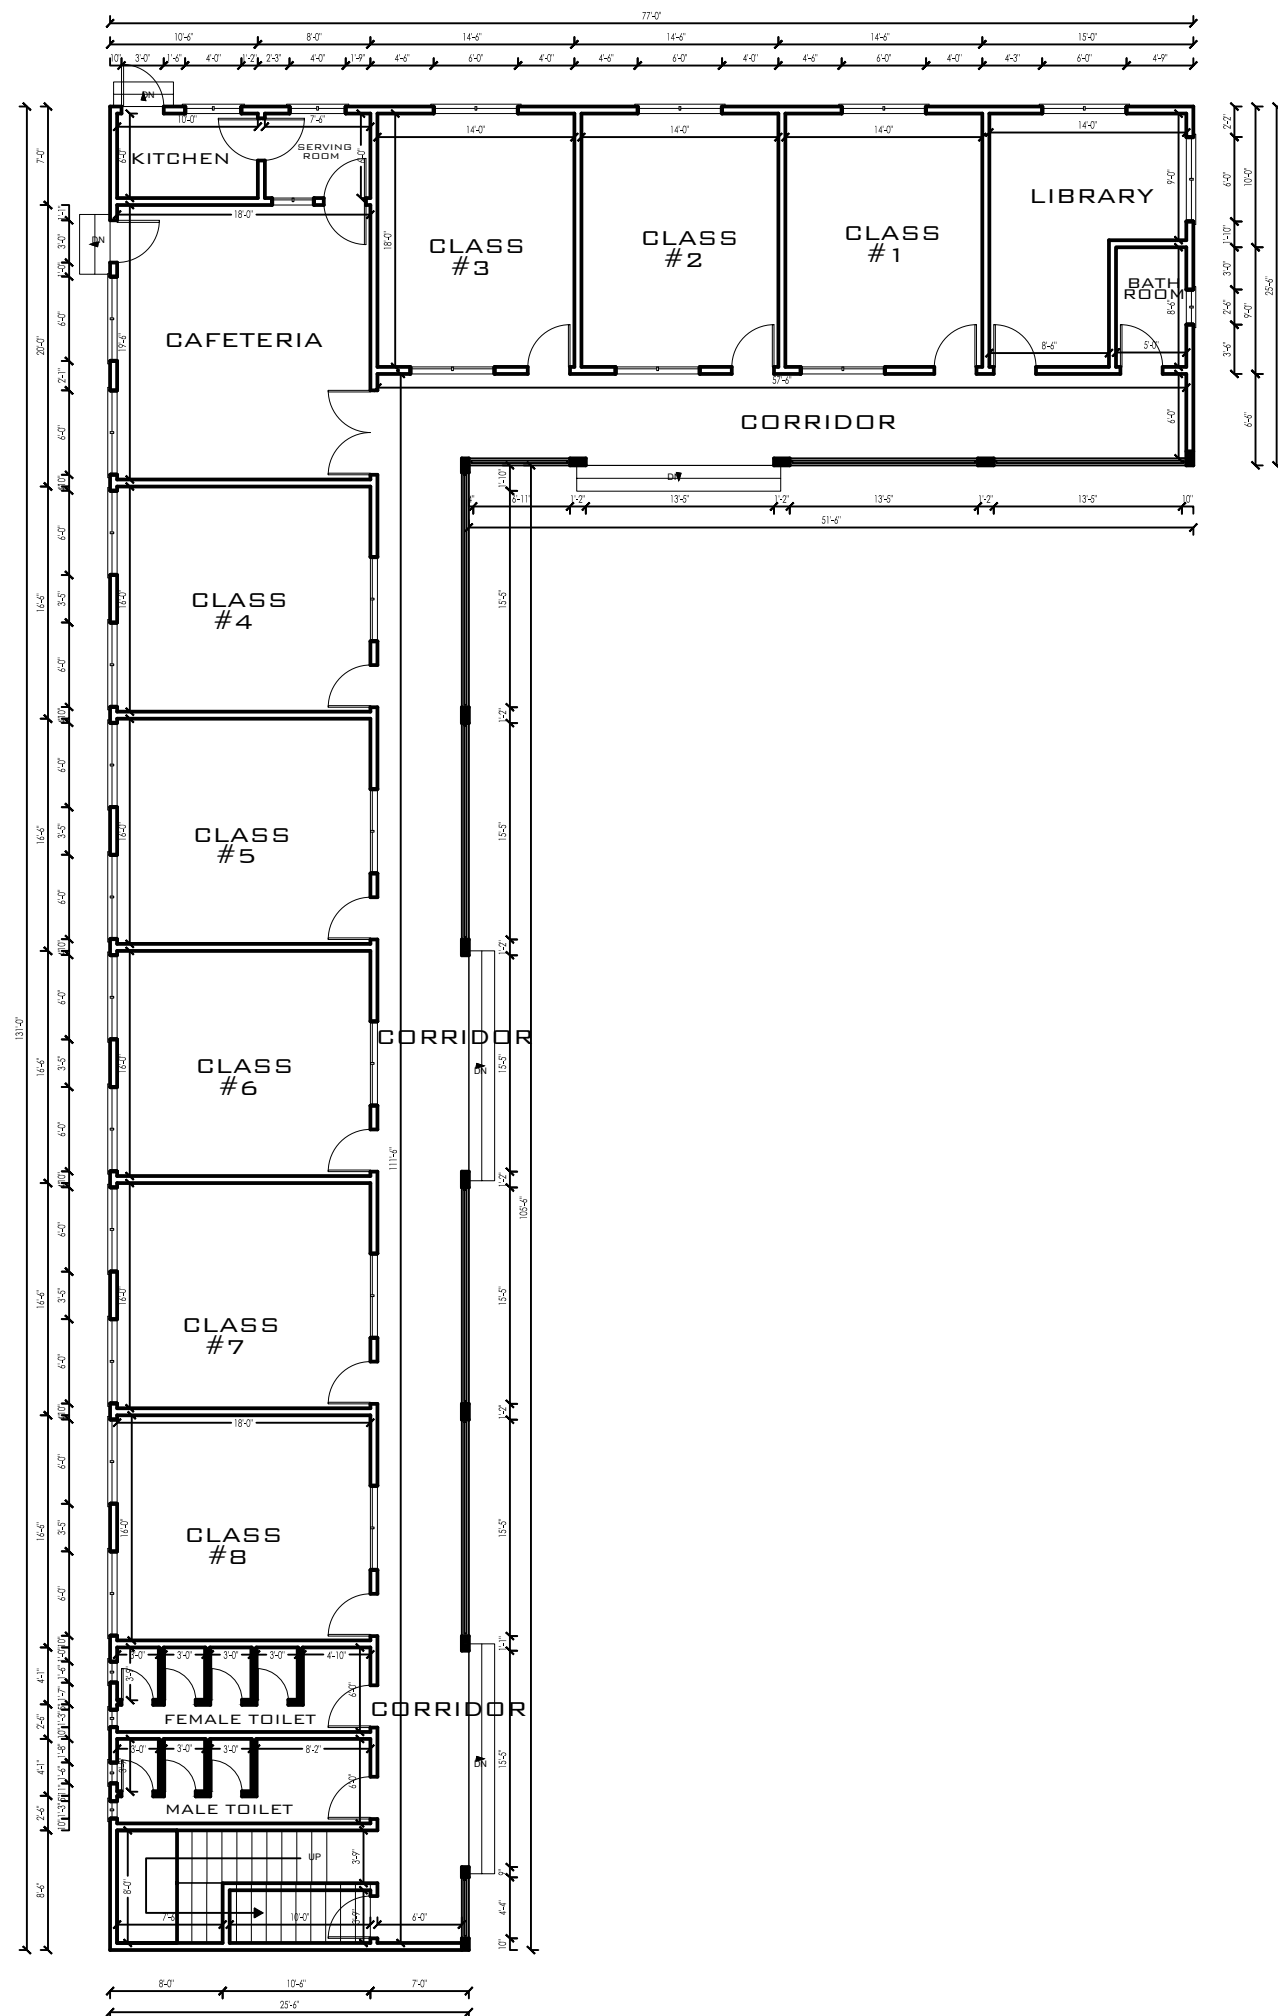

PROPOSE GROUND FLOOR PLAN
LIVING AREA
4653 sq ft



MOTTO:
QUALITY WITH PASSION

CLIENT :

HELP LIBERIA FOUNDATION

LOCATION: BUCHANAN CITY, LIBERIA

PROJECT :

PROPOSE: ELEMENTARY, JUNIOR & SENIOR HIGH SCHOOL

DRAWING TITLE :


PROPOSE GROUND FLOOR PLAN

FUTURE BUILDER & DEVELOPMENT GROUP INC.		SIGN
DESIGNED BY :	Mr. Alexander P.B. Yeaher Jr.	
DRAWING NO.	DATE	SCALE
A-208	OCTOBER 2020	1/8" = 1'-0"

Contact #: +231886232714/+231777544642

Email: fbdgincorporated@gmail.com

COPYRIGHT RESERVED
THIS DESIGN AND DETAIL ARE, AND
AT ALL TIMES THE EXCLUSIVE
PROPERTY OF HELP LIBERIA FOUNDATION
AND CAN NOT BE USED OR REPRODUCED
WITHOUT WRITTEN CONSENT.

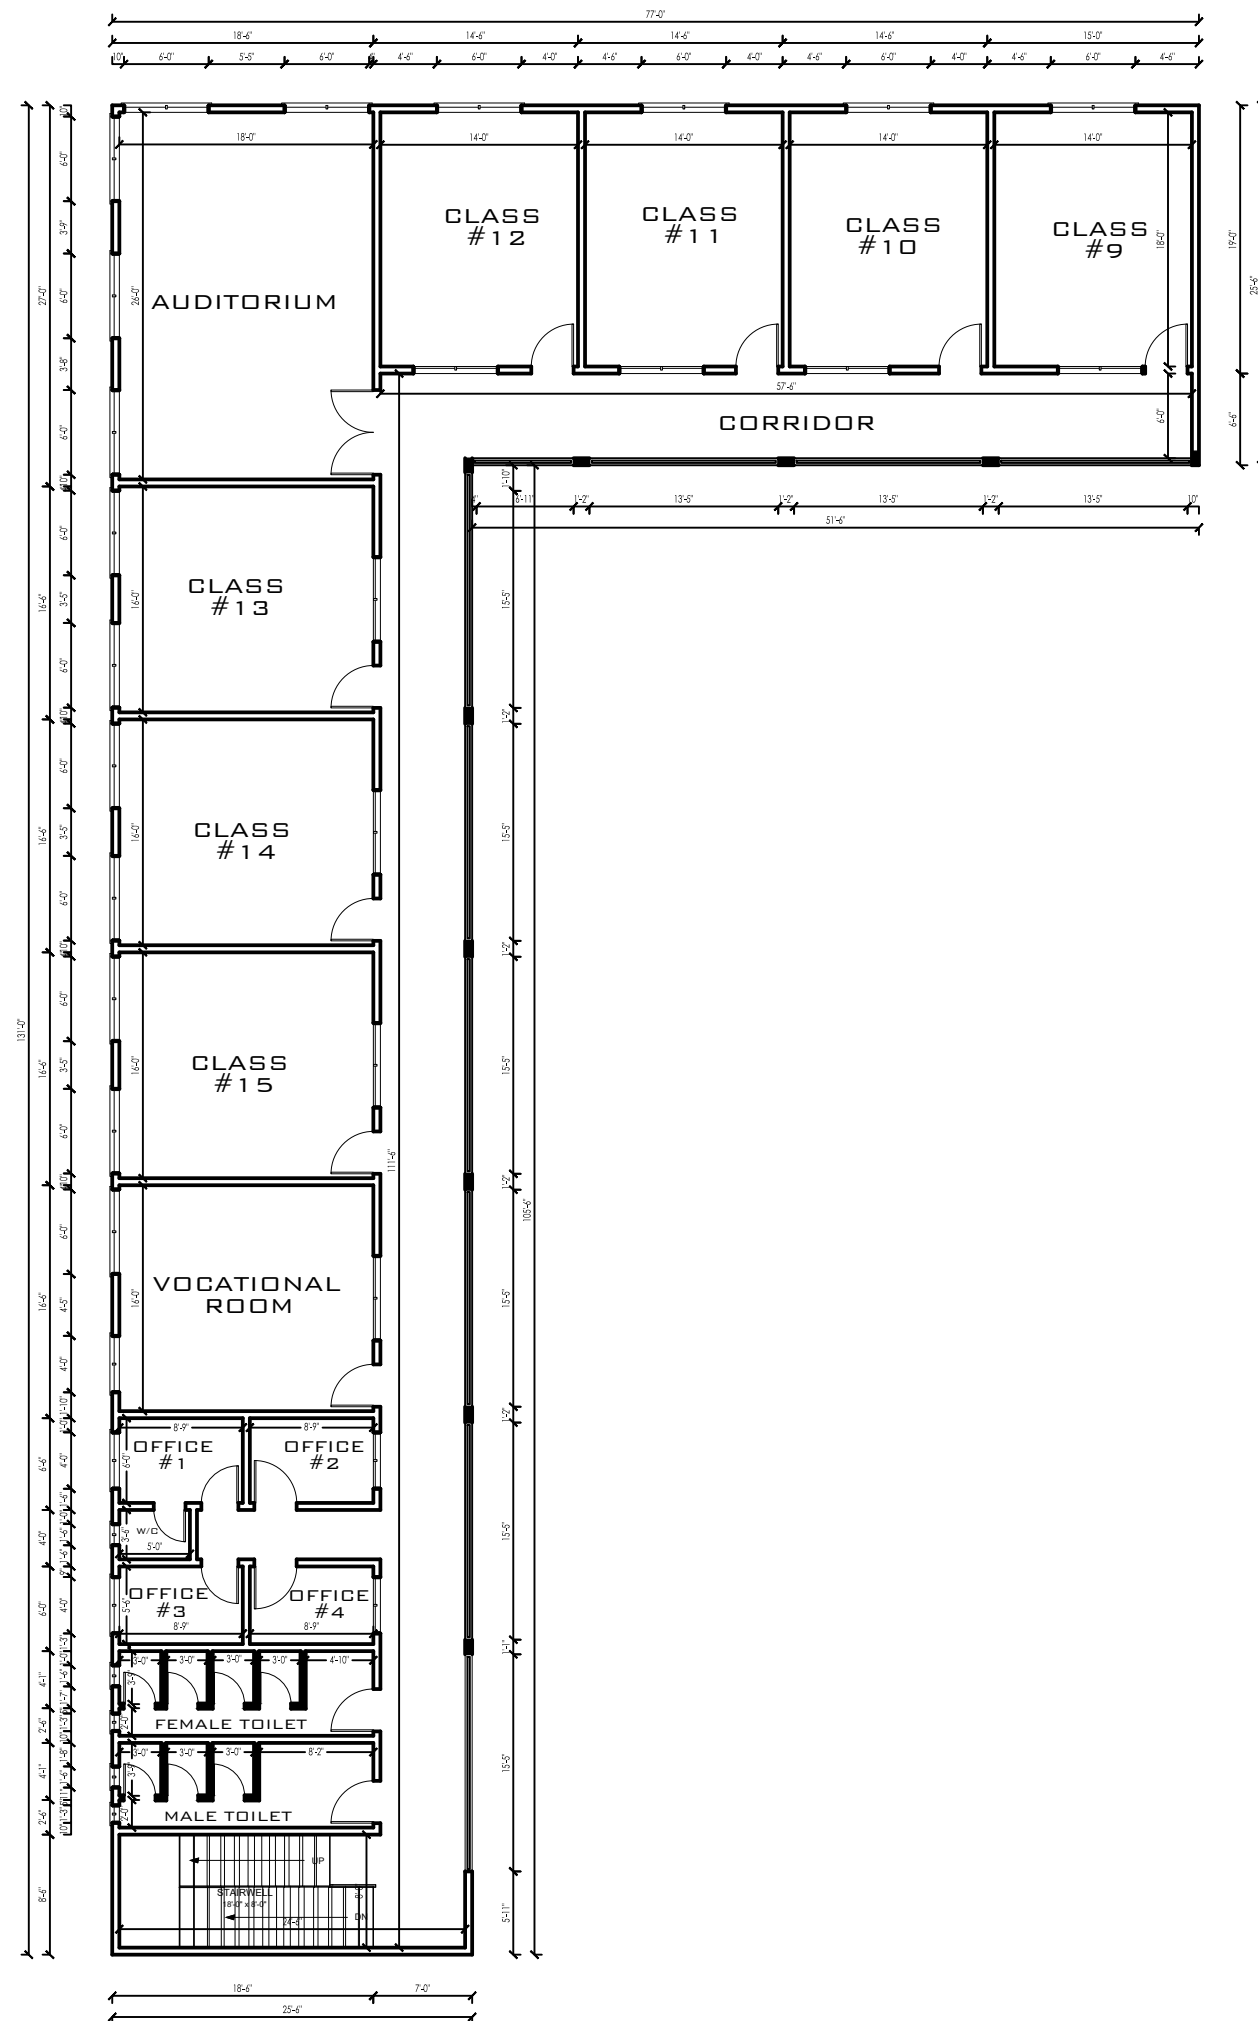

PROPOSE FIRST FLOOR PLAN
LIVING AREA
4503 SQ FT



**FUTURE BUILDERS &
DEVELOPMENT GROUP INC.**

MOTTO:
QUALITY WITH PASSION

CLIENT :

HELP LIBERIA FOUNDATION

LOCATION : BUCHANAN CITY, LIBERIA

PROJECT :

PROPOSE: ELEMENTARY, JUNIOR & SENIOR HIGH SCHOOL

DRAWING TITLE :


PROPOSE FIRST FLOOR PLAN

FUTURE BUILDER & DEVELOPMENT GROUP INC.		SIGN
DESIGNED BY :	Mr. Alexander P.B. Yeather Jr.	
DRAWING NO.	DATE	SCALE
A-209	OCTOBER 2020	1/8" = 1'-0"

Contact #: +231886232714/+231777544642

Email: fbdgincorporated@gmail.com

COPYRIGHT RESERVED
THIS DESIGN AND DETAIL ARE, AND
AT ALL TIMES THE EXCLUSIVE
PROPERTY OF HELP LIBERIA FOUNDATION
AND CAN NOT BE USED OR REPRODUCED
WITHOUT WRITTEN CONSENT.

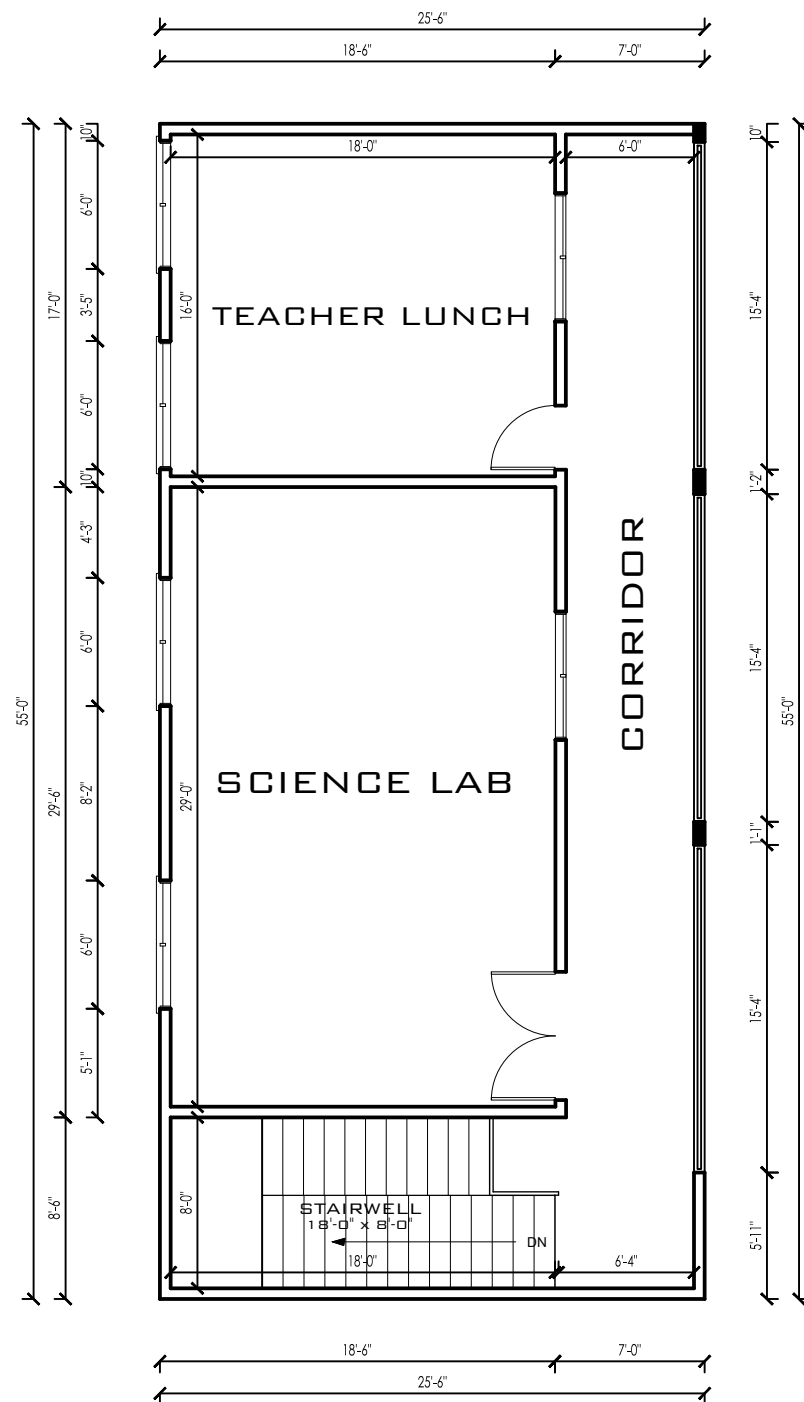

PROPOSE LAST FLOOR PLAN

A LIVING AREA
1251 SQ FT



MOTTO:
QUALITY WITH PASSION

CLIENT :
HELP LIBERIA FOUNDATION


LOCATION : BUCHANAN CITY, LIBERIA

PROJECT :
PROPOSE: ELEMENTARY, JUNIOR & SENIOR HIGH SCHOOL

DRAWING TITLE :
PROPOSE LAST FLOOR PLAN

FUTURE BUILDER & DEVELOPMENT GROUP INC.		SIGN
DESIGNED BY :	Mr. Alexander P.B. Yeaher Jr.	
DRAWING NO.	DATE	SCALE
A-210	OCTOBER 2020	1/8" = 1'-0"
Contact #; +231886232714/+231777544642		
Email: fbdgincorporated@gmail.com		

COPYRIGHT RESERVED
THIS DESIGN AND DETAIL ARE, AND
AT ALL TIMES THE EXCLUSIVE
PROPERTY OF HELP LIBERIA FOUNDATION
AND CAN NOT BE USED OR REPRODUCED
WITHOUT WRITTEN CONSENT.

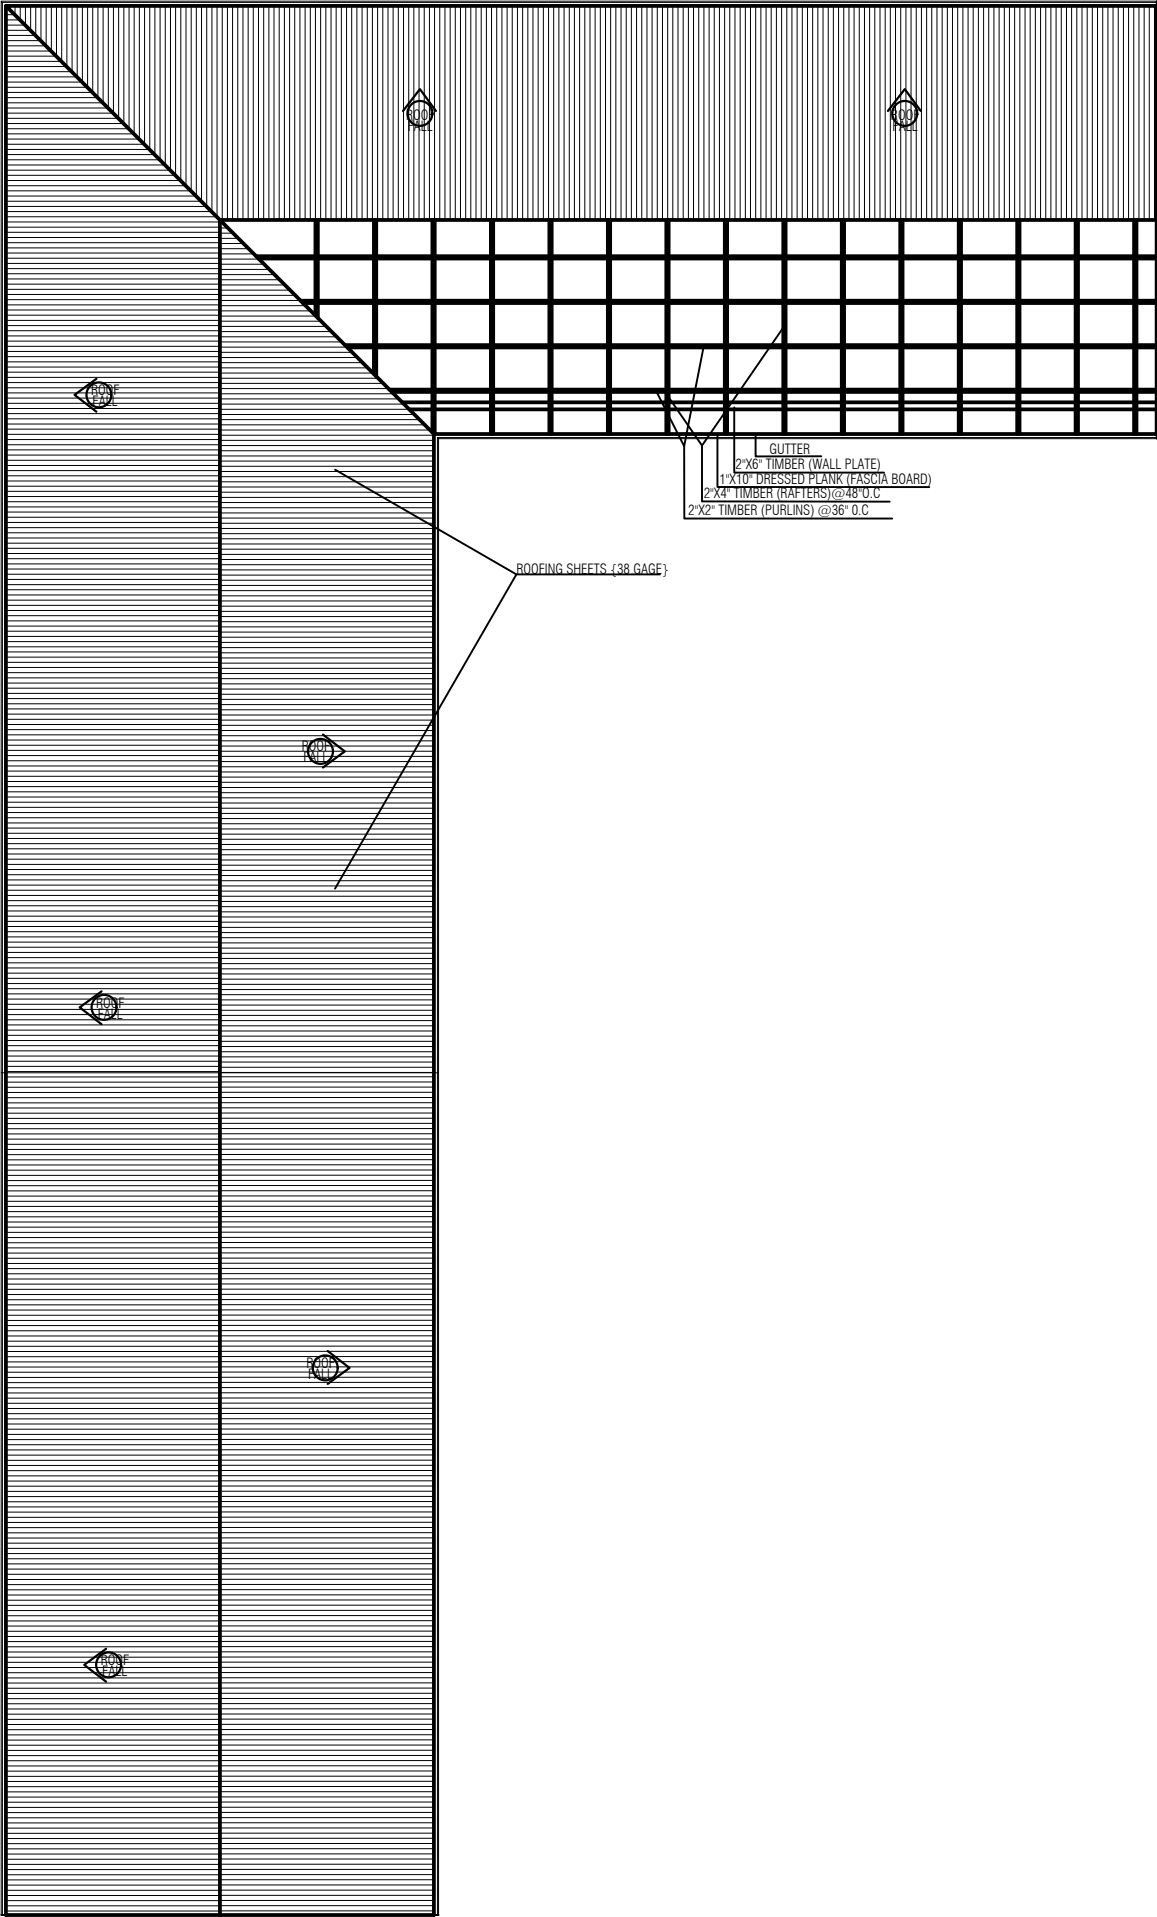

(A) PROPOSE ROOFING PLAN






MOTTO:
QUALITY WITH PASSION

CLIENT :
HELP LIBERIA FOUNDATION
LOCATION : BUCHANAN CITY, LIBERIA
PROJECT :
PROPOSE: ELEMENTARY, JUNIOR & SENIOR HIGH SCHOOL

DRAWING TITLE :
PROPOSE ROOFING PLAN

FUTURE BUILDER & DEVELOPMENT GROUP INC.		SIGN
DESIGNED BY :	Mr. Alexander P.B. Yeaher Jr.	
DRAWING NO.	DATE	SCALE
A-211	OCTOBER 2020	1/8" = 1'-0"
Contact #; +231886232714/+231777544642		
Email: fbdgincorporated@gmail.com		

COPYRIGHT RESERVED
THIS DESIGN AND DETAIL ARE, AND
AT ALL TIMES THE EXCLUSIVE
PROPERTY OF HELP LIBERIA FOUNDATION
AND CAN NOT BE USED OR REPRODUCED
WITHOUT WRITTEN CONSENT.

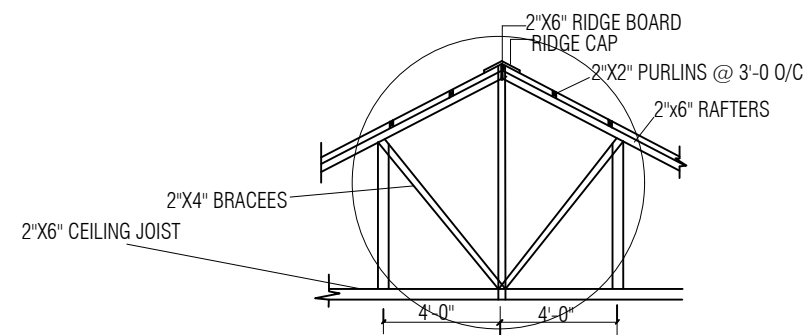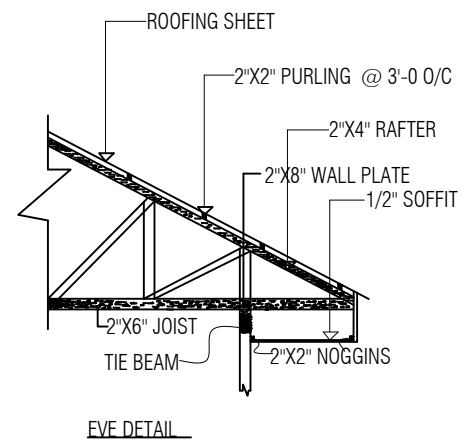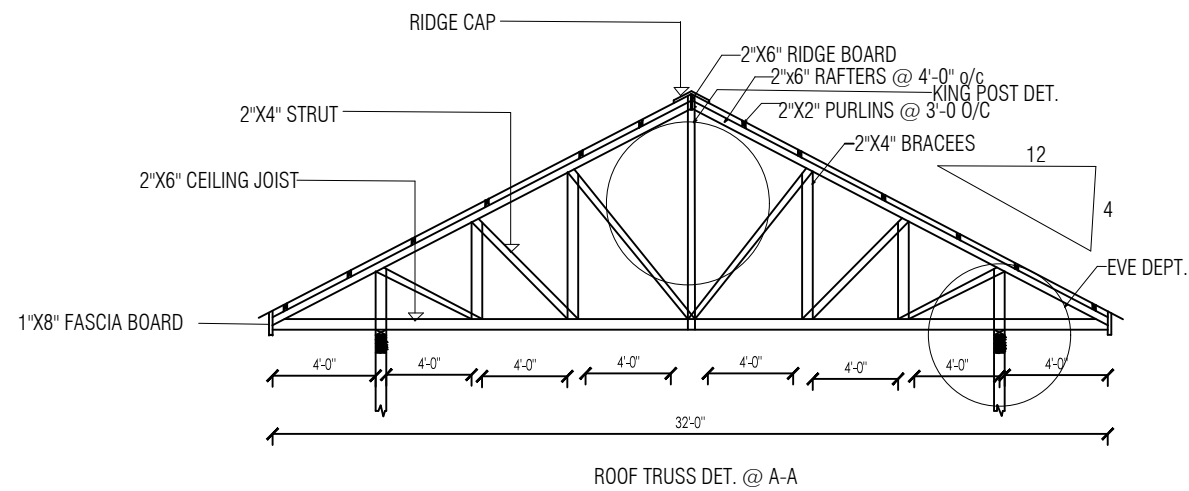

MOTTO:
QUALITY WITH PASSION

CLIENT :

HELP LIBERIA FOUNDATION

LOCATION : BUCHANAN CITY, LIBERIA

PROJECT :

PROPOSE: ELEMENTARY, JUNIOR & SENIOR HIGH SCHOOL


DRAWING TITLE :

ROOFING TRUSS DETAILS

FUTURE BUILDER & DEVELOPMENT GROUP INC.		SIGN
DESIGNED BY :	Mr. Alexander P.B. Yeaher Jr.	
DRAWING NO.	DATE	SCALE
A-212	OCTOBER 2020	1/8" = 1'-0"
Contact #; +231886232714/+231777544642		
Email: fbdgincorporated@gmail.com		

COPYRIGHT RESERVED
THIS DESIGN AND DETAIL ARE, AND
AT ALL TIMES THE EXCLUSIVE
PROPERTY OF HELP LIBERIA FOUNDATION
AND CAN NOT BE USED OR REPRODUCED
WITHOUT WRITTEN CONSENT.

(A) ROOFING TRUSS DETAILS

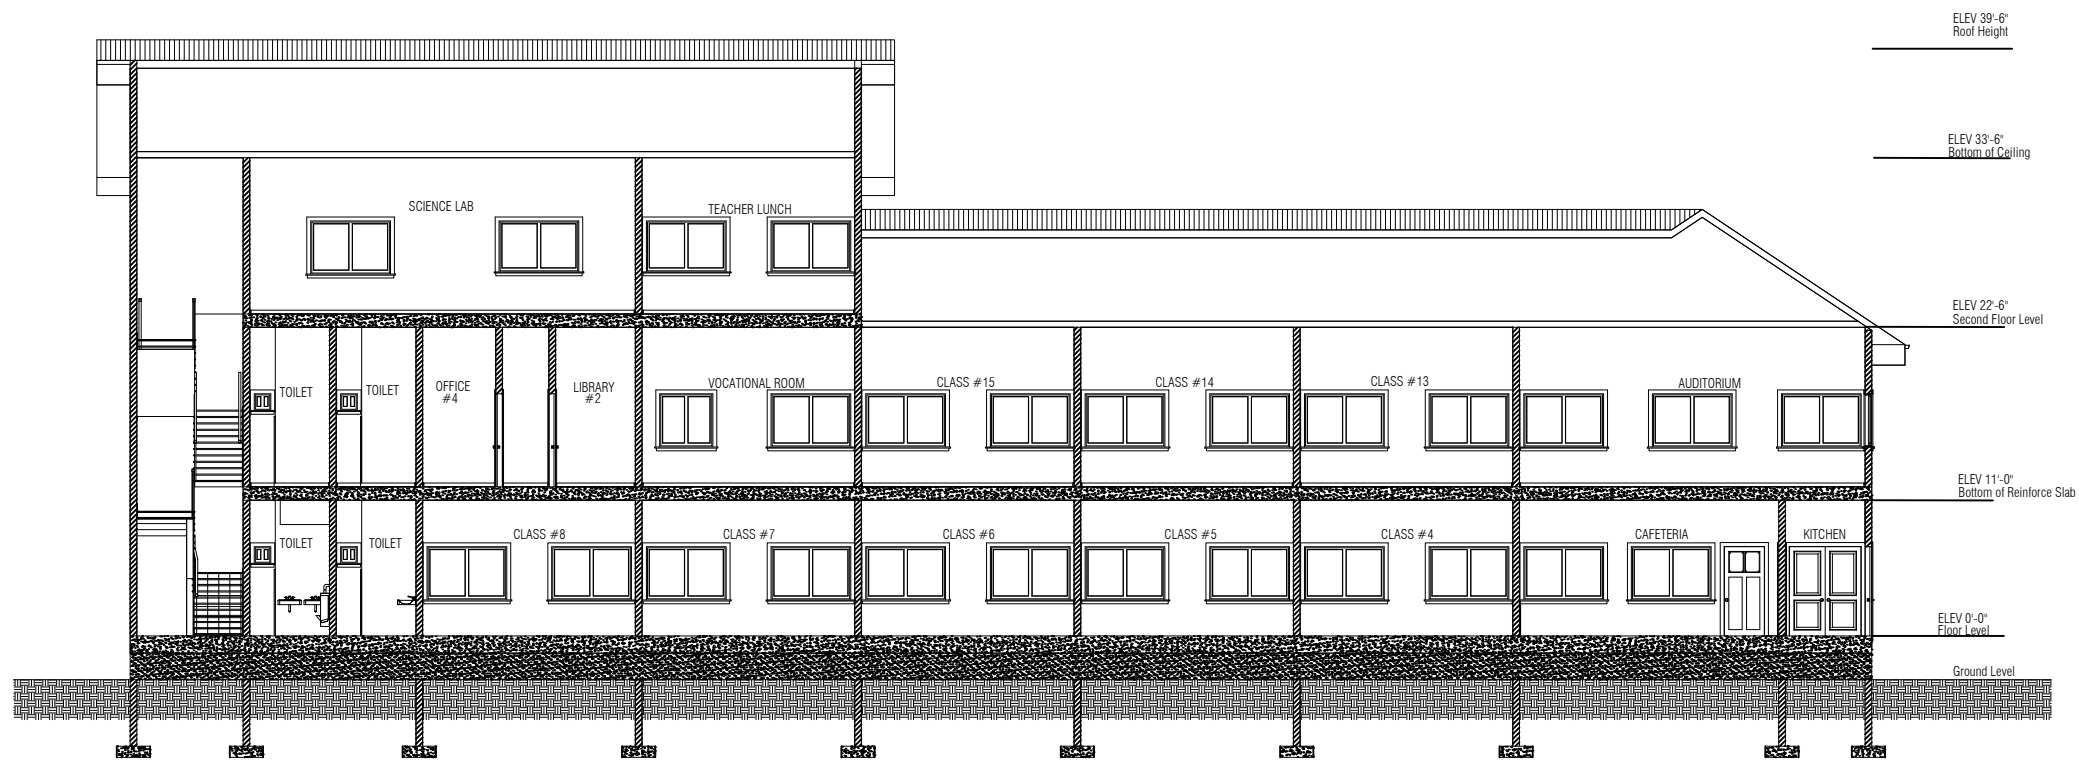

A SECTION A - A



FUTURE BUILDERS &
DEVELOPMENT GROUP INC.


MOTTO:
QUALITY WITH PASSION

CLIENT :
HELP LIBERIA FOUNDATION
LOCATION : BUCHANAN CITY, LIBERIA
PROJECT :
PROPOSE ELEMENTARY, JUNIOR & SENIOR HIGH SCHOOL

DRAWING TITLE :
SECTION A - A

FUTURE BUILDER & DEVELOPMENT GROUP INC.	SIGN
DESIGNED BY : Mr. Alexander P.B. Yeather Jr.	
DRAWING NO. A-213	DATE OCTOBER 2020
	SCALE 1/8" = 1'-0"
Contact #: +231886232714/+231777544642	
Email: fbdgincorporated@gmail.com	

COPYRIGHT RESERVED
THIS DESIGN AND DETAIL ARE, AND
AT ALL TIMES THE EXCLUSIVE
PROPERTY OF HELP LIBERIA FOUNDATION
AND CAN NOT BE USED OR REPRODUCED
WITHOUT WRITTEN CONSENT.

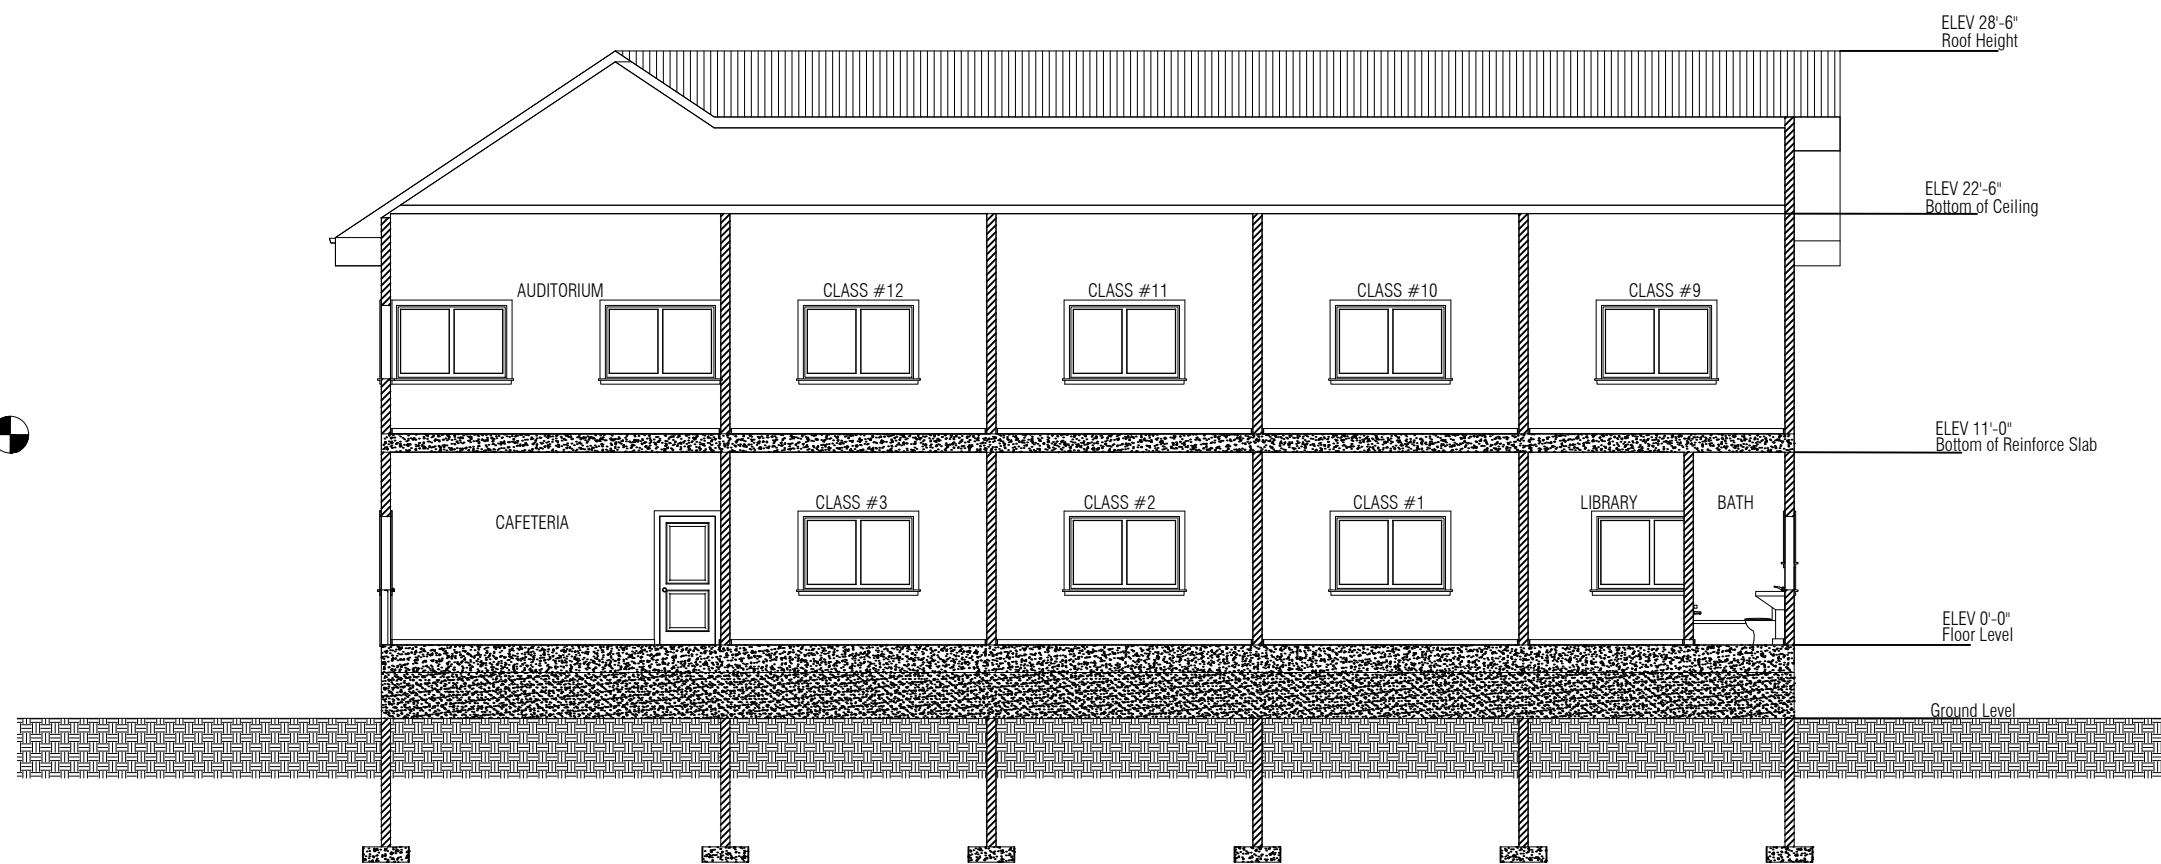

SECTION B - B



**FUTURE BUILDERS &
DEVELOPMENT GROUP INC.**

MOTTO:
QUALITY WITH PASSION

CLIENT :
HELP LIBERIA FOUNDATION

LOCATION : BUCHANAN CITY, LIBERIA

PROJECT :
PROPOSE ELEMENTARY, JUNIOR & SENIOR HIGH SCHOOL

DRAWING TITLE :
SECTION B - B

FUTURE BUILDER & DEVELOPMENT GROUP INC.		SIGN
DESIGNED BY :	Mr. Alexander P.B. Yeaher Jr.	
DRAWING NO.	DATE	SCALE
A-214	OCTOBER 2020	1/8" = 1'-0"
Contact #; +231886232714/+231777544642		
Email: fbdgincorporated@gmail.com		

COPYRIGHT RESERVED
THIS DESIGN AND DETAIL ARE, AND
AT ALL TIMES THE EXCLUSIVE
PROPERTY OF HELP LIBERIA FOUNDATION
AND CAN NOT BE USED OR REPRODUCED
WITHOUT WRITTEN CONSENT.



Ⓐ STAIRS CASE ELEVATION



**FUTURE BUILDERS &
DEVELOPMENT GROUP INC.**


MOTTO:
QUALITY WITH PASSION

CLIENT :
HELP LIBERIA FOUNDATION
LOCATION : BUCHANAN CITY, LIBERIA
PROJECT :
PROPOSE ELEMENTARY, JUNIOR & SENIOR HIGH SCHOOL

DRAWING TITLE :
STAIRS CASE ELEVATION

FUTURE BUILDER & DEVELOPMENT GROUP INC.		SIGN
DESIGNED BY :	Mr. Alexander P.B. Yeaher Jr.	
DRAWING NO.	DATE	SCALE
A-215	OCTOBER 2020	1/8" = 1'-0"
Contact #; +231886232714/+231777544642		
Email: fbdgincorporated@gmail.com		


COPYRIGHT RESERVED
THIS DESIGN AND DETAIL ARE, AND
AT ALL TIMES THE EXCLUSIVE
PROPERTY OF HELP LIBERIA FOUNDATION
AND CAN NOT BE USED OR REPRODUCED
WITHOUT WRITTEN CONSENT.

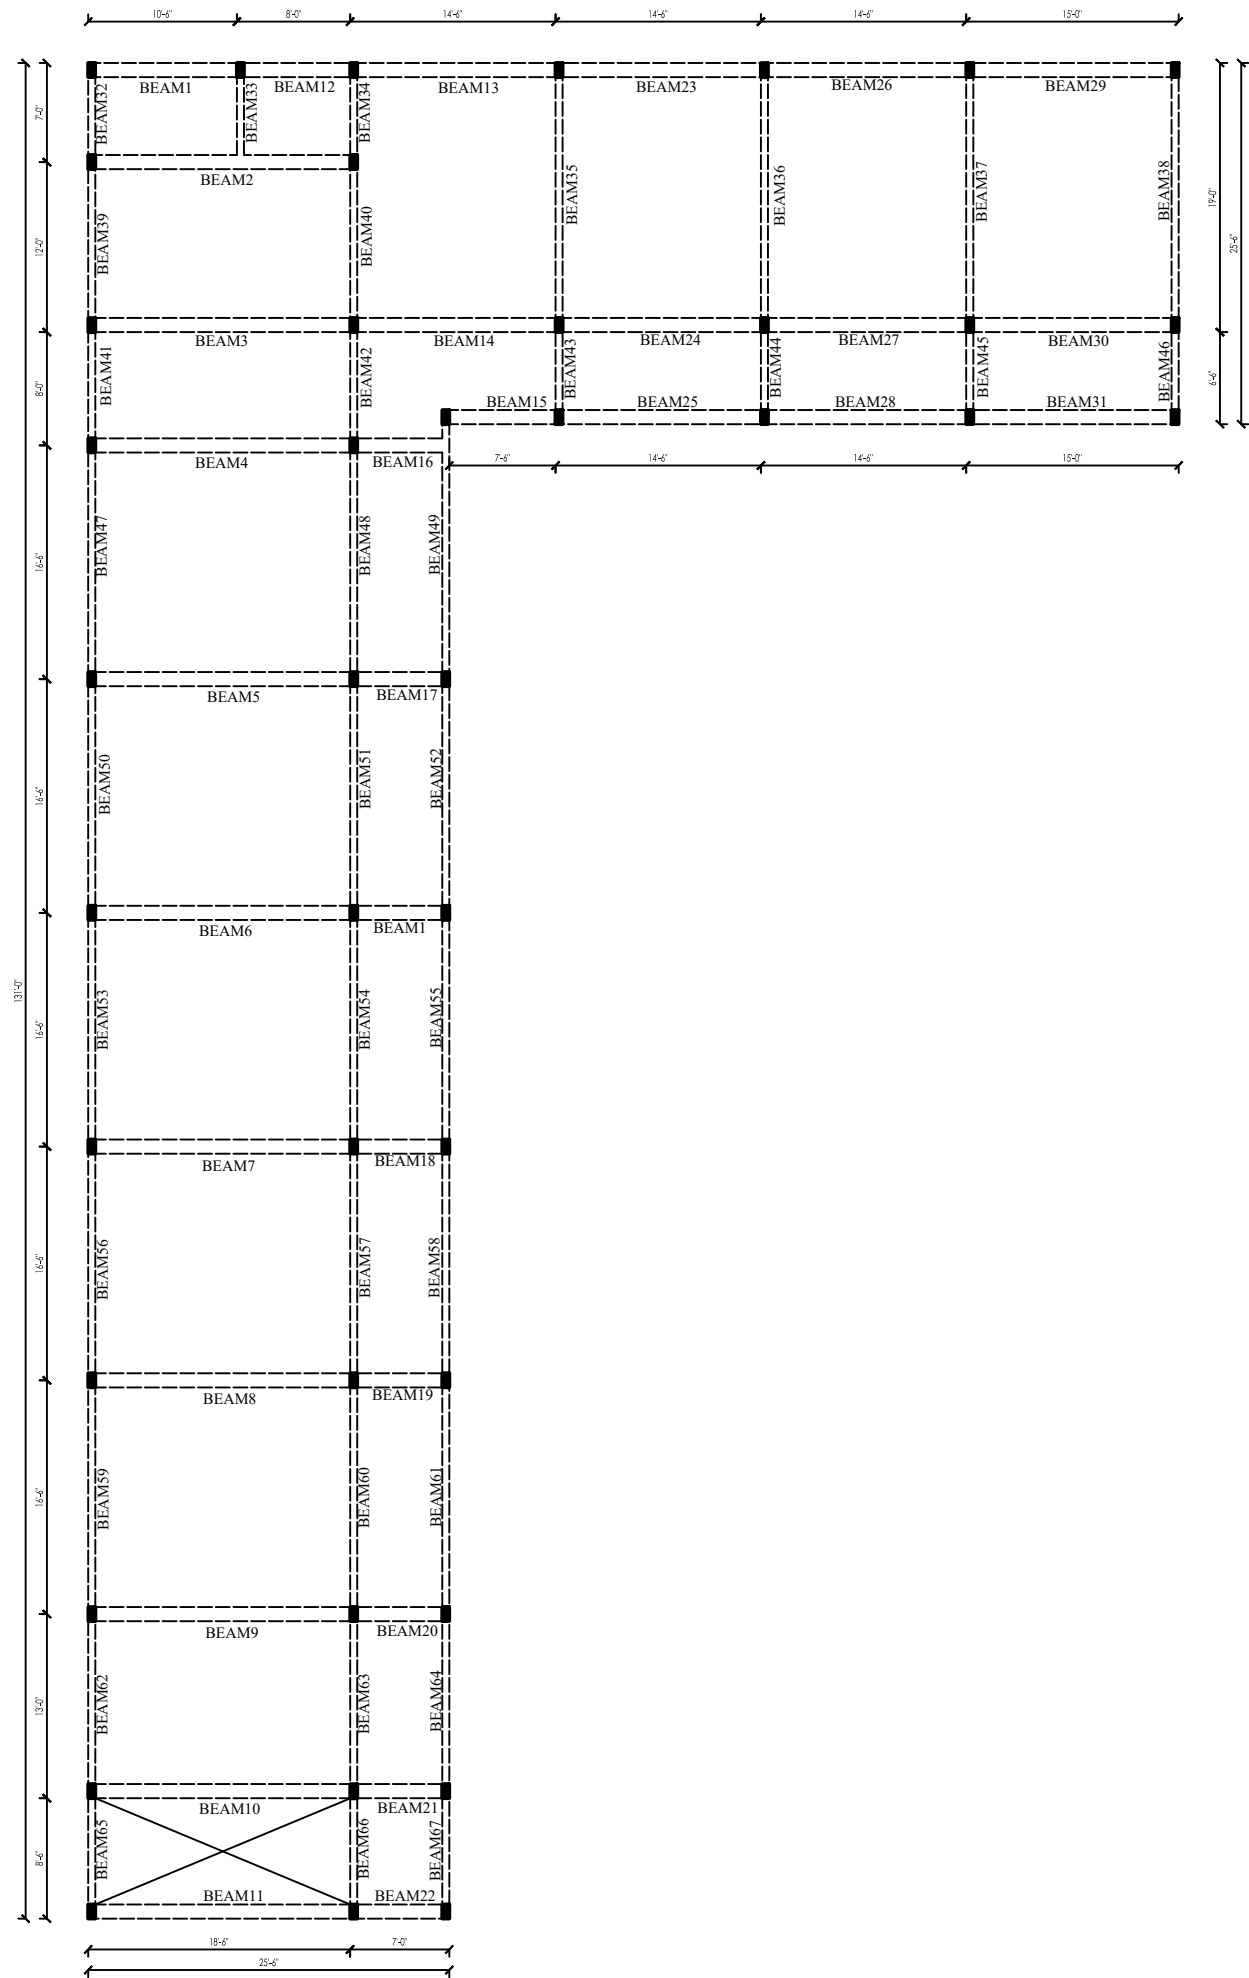

(A) BEAM LAYOUTS



MOTTO: QUALITY WITH PASSION		
CLIENT : HELP LIBERIA FOUNDATION		
LOCATION : BUCHANAN CITY, LIBERIA		
PROJECT : PROPOSE: ELEMENTARY, JUNIOR & SENIOR HIGH SCHOOL		
DRAWING TITLE : BEAM LAYOUTS		
FUTURE BUILDER & DEVELOPMENT GROUP INC.		SIGN
DESIGNED BY :	Mr. Alexander P.B. Yeaher Jr.	
DRAWING NO.	DATE	SCALE
A-216	OCTOBER 2020	1/8" = 1'-0"
Contact #; +231886232714/+231777544642		
Email: fbdgincorporated@gmail.com		
COPYRIGHT RESERVED THIS DESIGN AND DETAIL ARE, AND AT ALL TIMES THE EXCLUSIVE PROPERTY OF HELP LIBERIA FOUNDATION AND CAN NOT BE USED OR REPRODUCED WITHOUT WRITTEN CONSENT.		

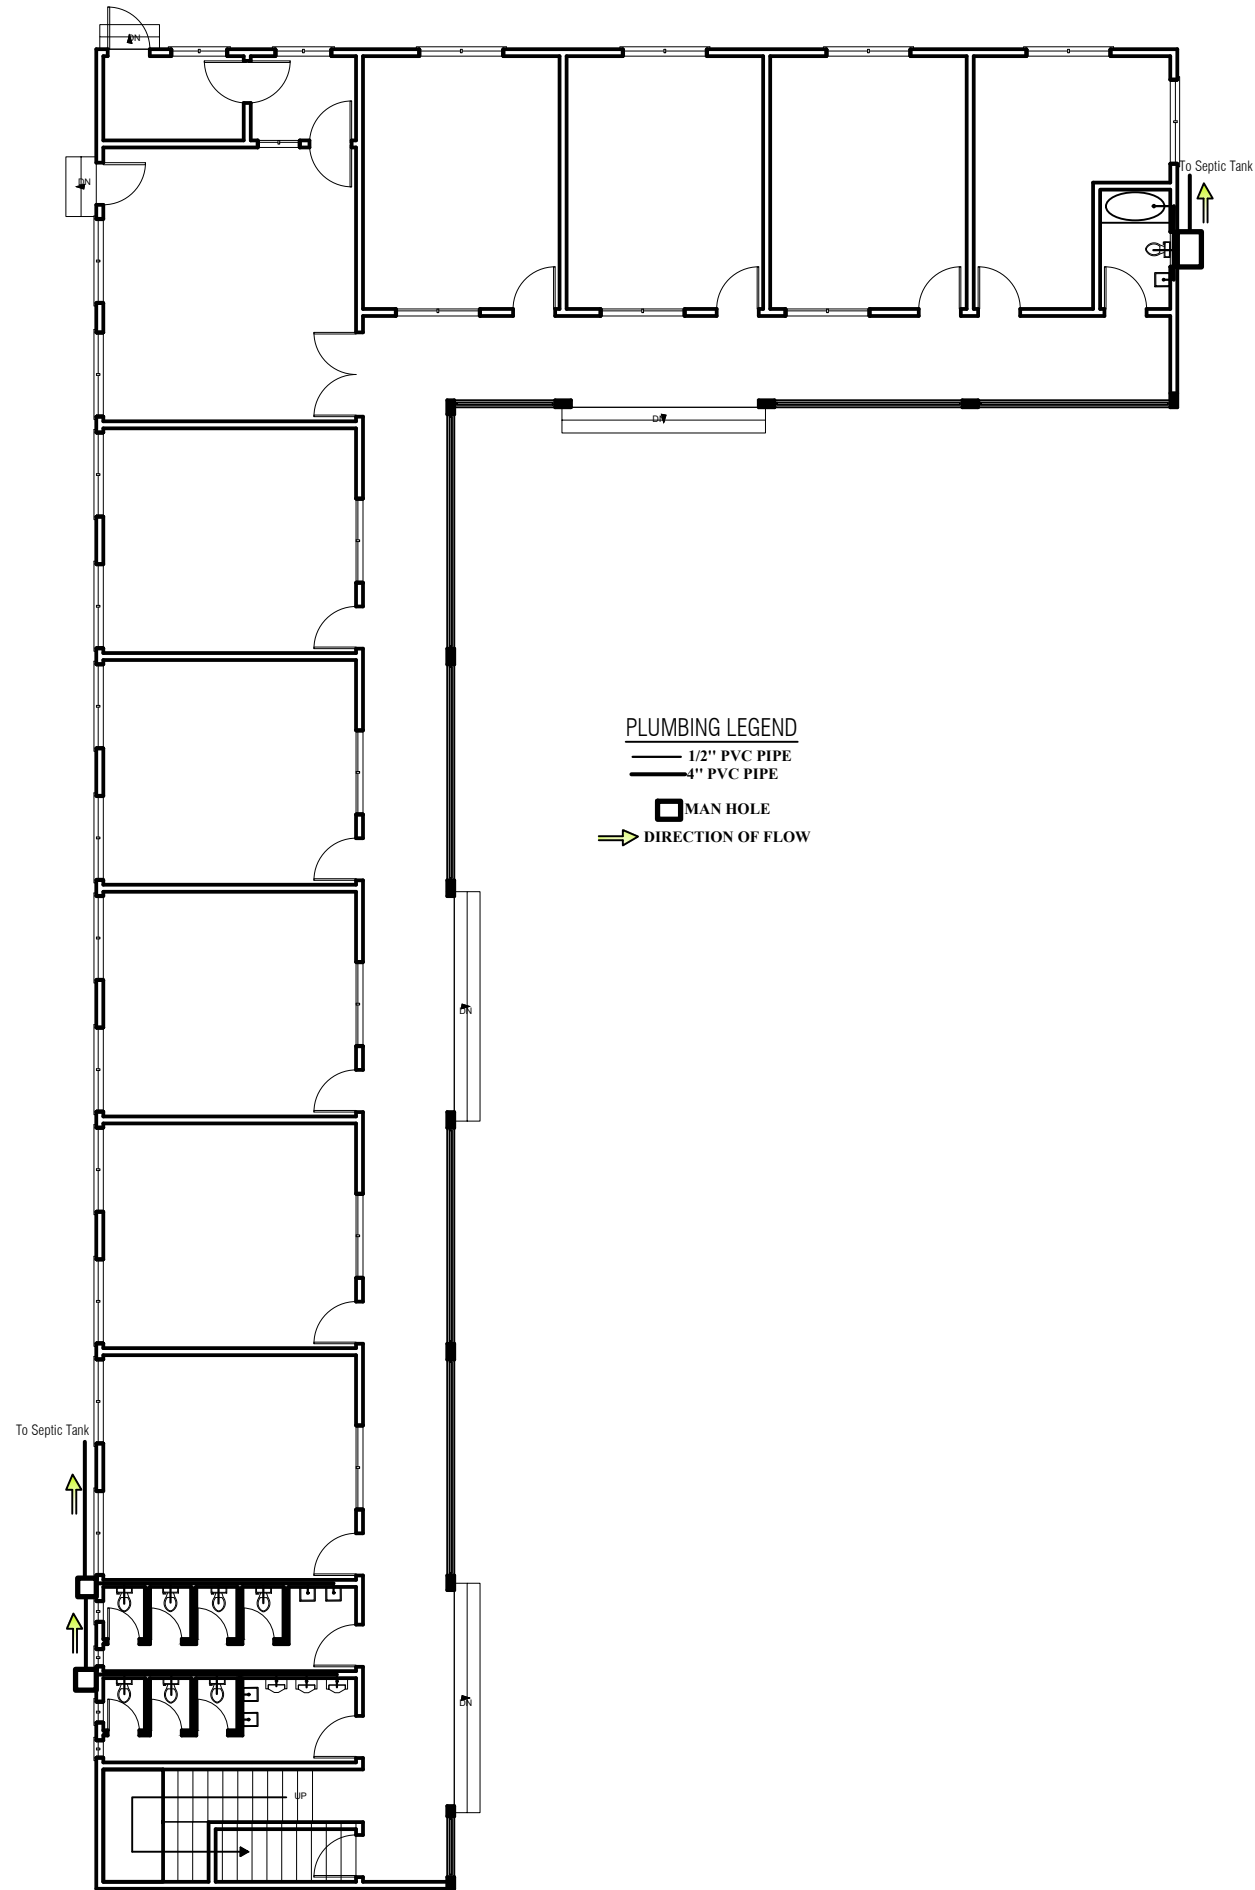

A PROPOSE GROUND FLOOR PLUMBING PLAN



MOTTO:
QUALITY WITH PASSION

CLIENT :
HELP LIBERIA FOUNDATION


LOCATION : BUCHANAN CITY, LIBERIA

PROJECT :
PROPOSE: ELEMENTARY, JUNIOR & SENIOR HIGH SCHOOL

DRAWING TITLE :
PROPOSE GROUND FLOOR
PLUMBING PLAN

FUTURE BUILDER & DEVELOPMENT GROUP INC.		SIGN
DESIGNED BY :	Mr. Alexander P.B. Yeaher Jr.	
DRAWING NO.	DATE	SCALE
A-217	OCTOBER 2020	1/8" = 1'-0"
Contact # : +231886232714/+23177544642		
Email: fbdgincorporated@gmail.com		

COPYRIGHT RESERVED
THIS DESIGN AND DETAIL ARE, AND
AT ALL TIMES THE EXCLUSIVE
PROPERTY OF HELP LIBERIA FOUNDATION
AND CAN NOT BE USED OR REPRODUCED
WITHOUT WRITTEN CONSENT.

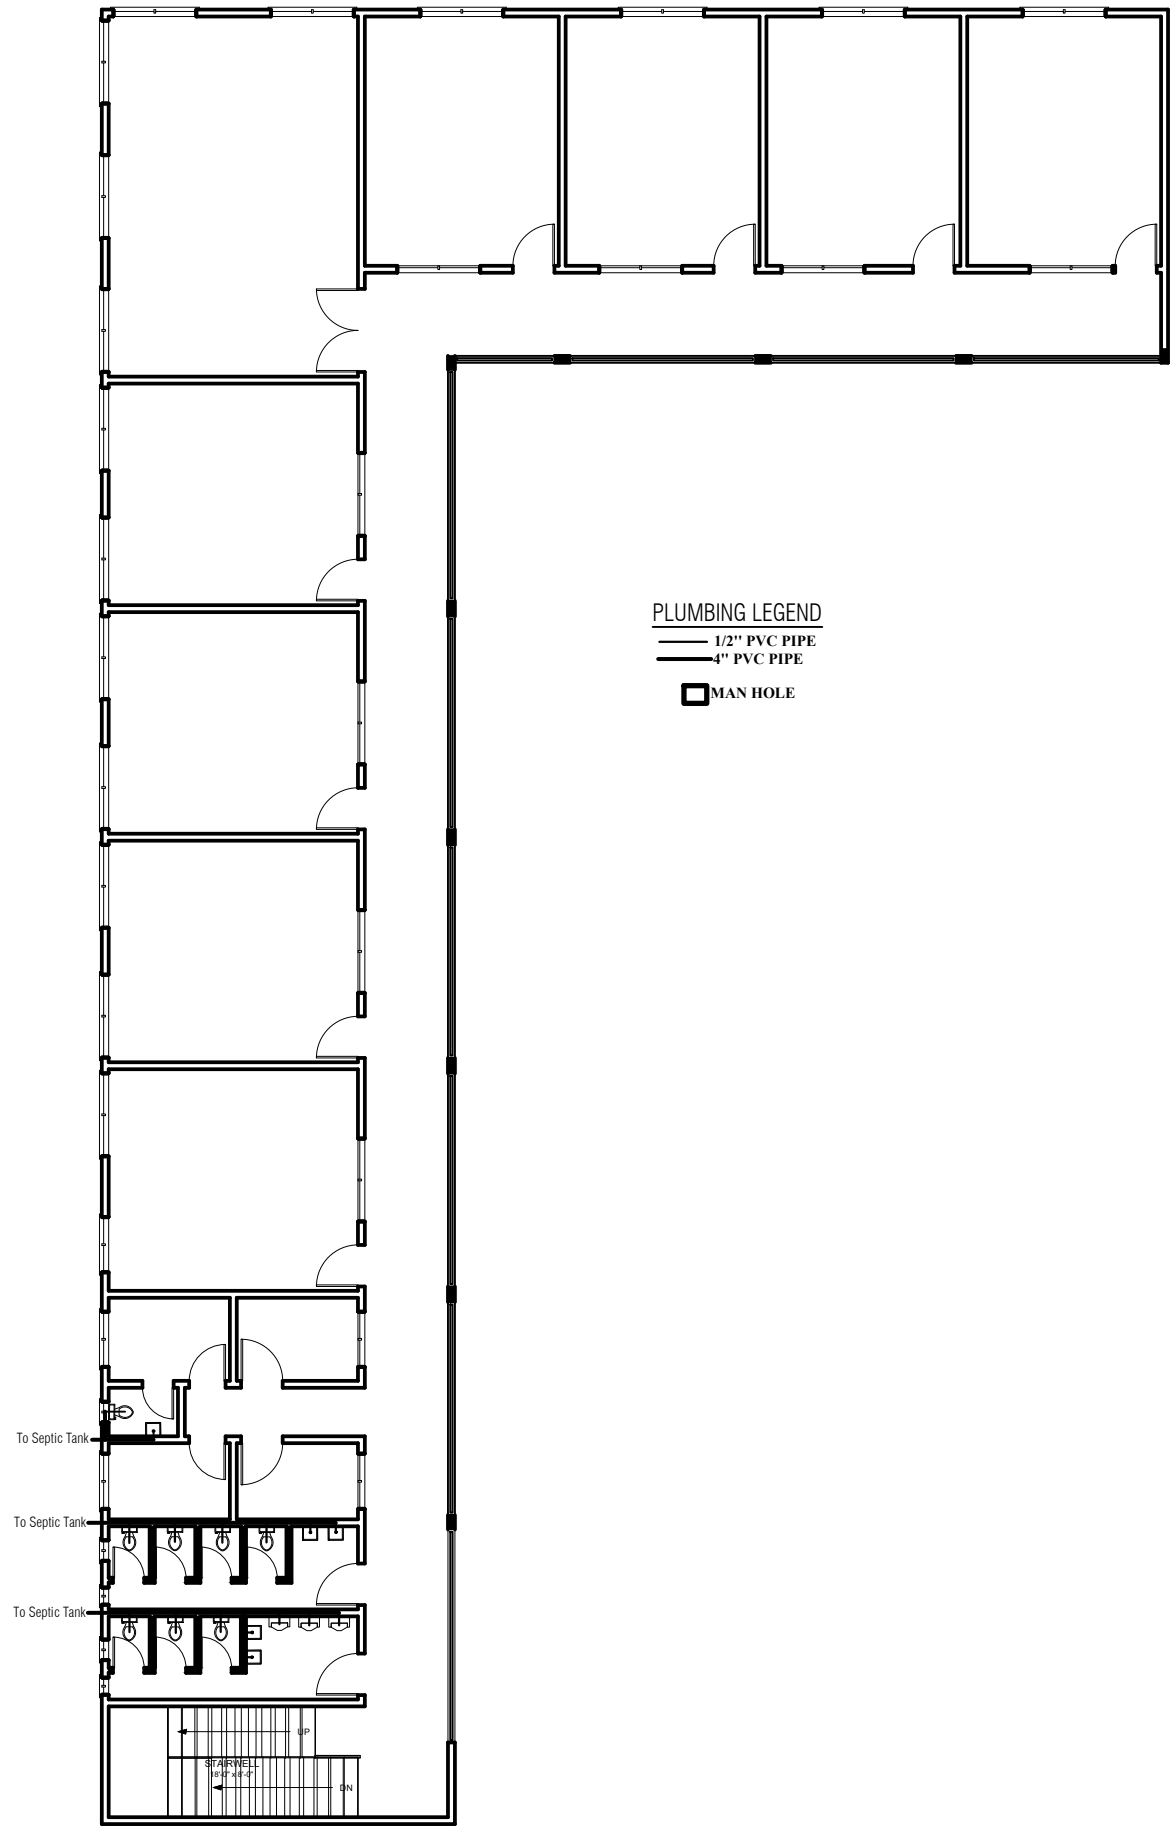

A PROPOSE FIRST FLOOR PLUMBING PLAN



MOTTO:
QUALITY WITH PASSION

CLIENT :
HELP LIBERIA FOUNDATION


LOCATION : BUCHANAN CITY, LIBERIA

PROJECT :
PROPOSE: ELEMENTARY, JUNIOR & SENIOR HIGH SCHOOL

DRAWING TITLE :
PROPOSE FIRST FLOOR PLUMBING
PLAN

FUTURE BUILDER & DEVELOPMENT GROUP INC.		SIGN
DESIGNED BY :	Mr. Alexander P.B. Yeather Jr.	
DRAWING NO.	DATE	SCALE
A-218	OCTOBER 2020	1/8" = 1'-0"
Contact #; +231886232714/+231777544642		
Email: fbdgincorporated@gmail.com		

COPYRIGHT RESERVED
THIS DESIGN AND DETAIL ARE, AND
AT ALL TIMES THE EXCLUSIVE
PROPERTY OF HELP LIBERIA FOUNDATION
AND CAN NOT BE USED OR REPRODUCED
WITHOUT WRITTEN CONSENT.

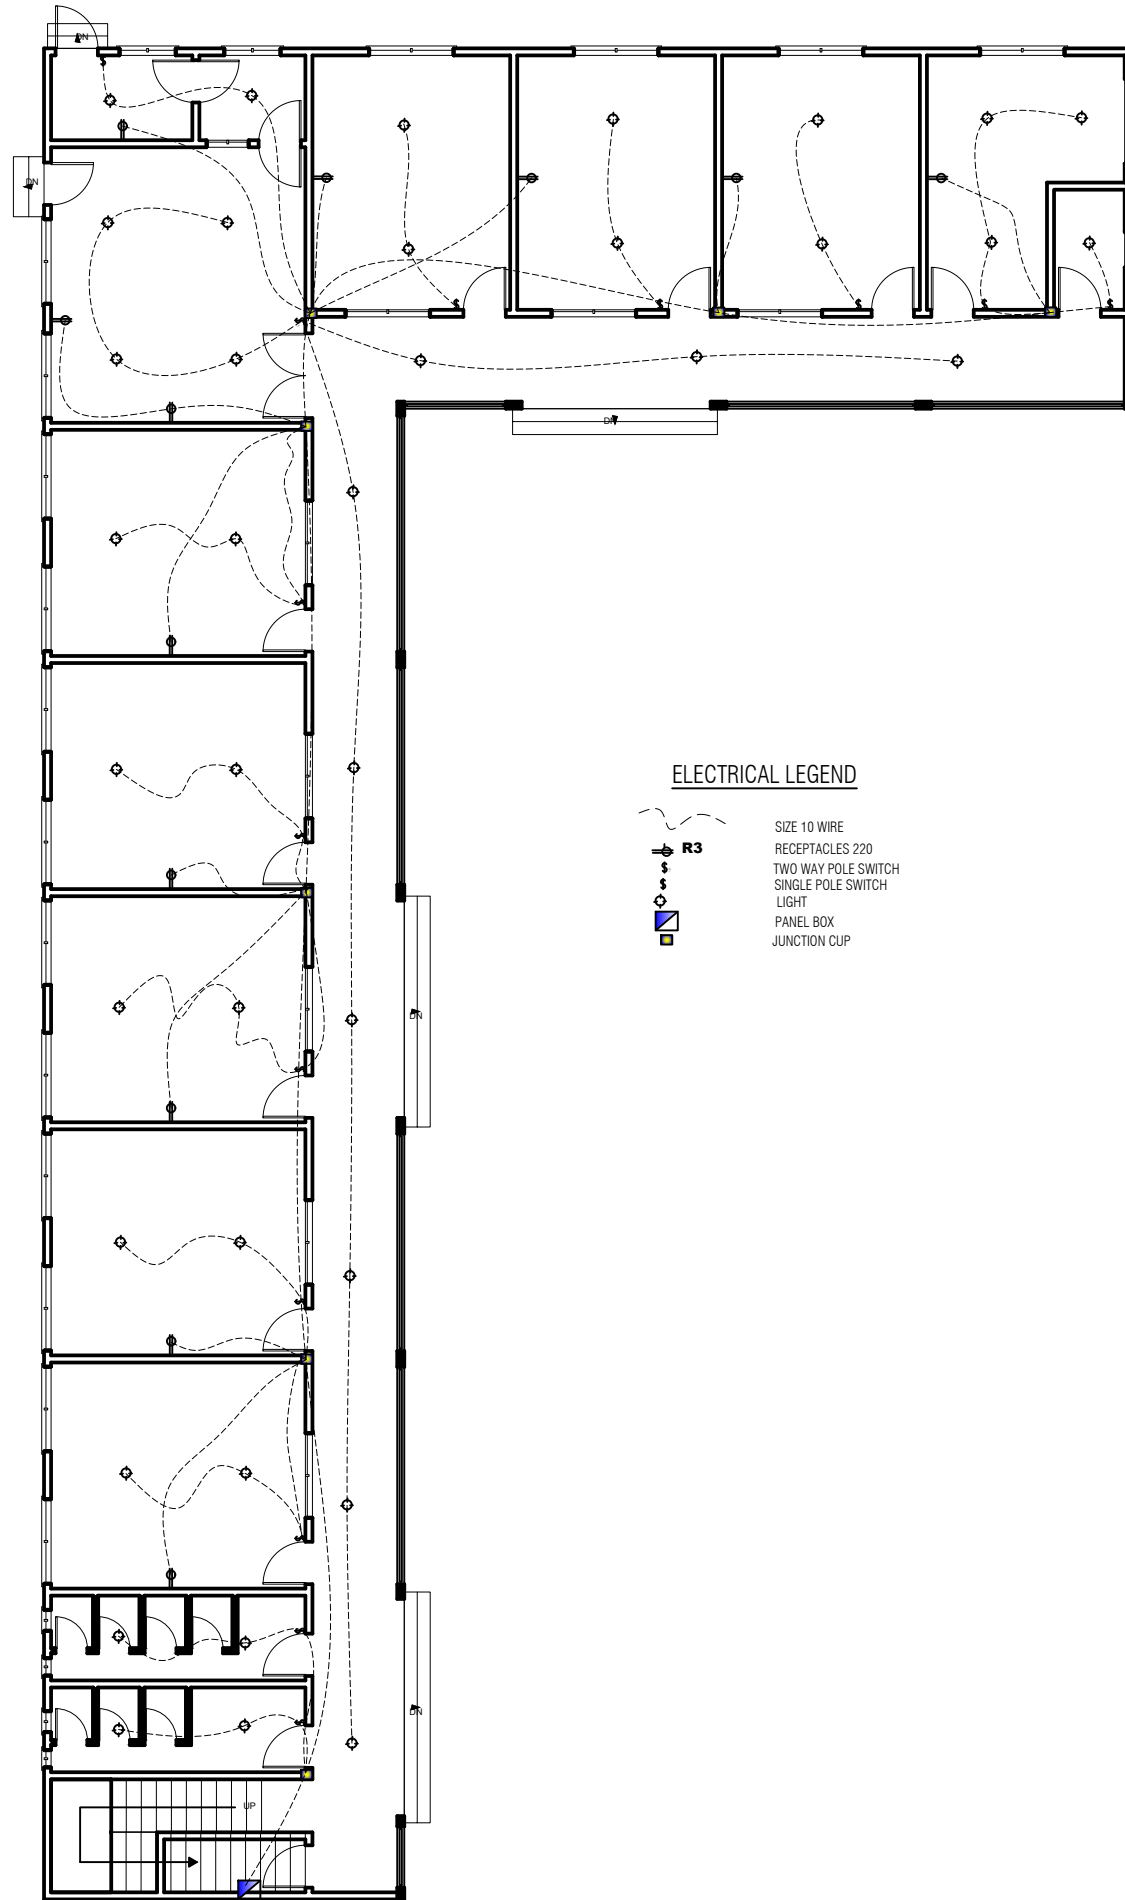

A PROPOSE GROUND FLOOR ELECTRICAL PLAN

FUTURE BUILDERS & DEVELOPMENT GROUP INC.

MOTTO:
QUALITY WITH PASSION

CLIENT :

HELP LIBERIA FOUNDATION

LOCATION : **IBUCHANAN CITY, LIBERIA**

PROJECT :


PROPOSE: ELEMENTARY, JUNIOR & SENIOR HIGH SCHOOL

DRAWING TITLE :

PROPOSE GROUND FLOOR ELECTRICAL PLAN

FUTURE BUILDER & DEVELOPMENT GROUP INC.		SIGN
DESIGNED BY :	Mr. Alexander P.B. Yeager Jr.	
DRAWING NO.	DATE	SCALE
A-219	OCTOBER 2020	1/8" = 1'-0"
Contact #: +231886232714/+231777544642		
Email: ibdgincorporated@gmail.com		

COPYRIGHT RESERVED
THIS DESIGN AND DETAIL ARE, AND
AT ALL TIMES THE EXCLUSIVE
PROPERTY OF HELP LIBERIA FOUNDATION
AND CAN NOT BE USED OR REPRODUCED
WITHOUT WRITTEN CONSENT.

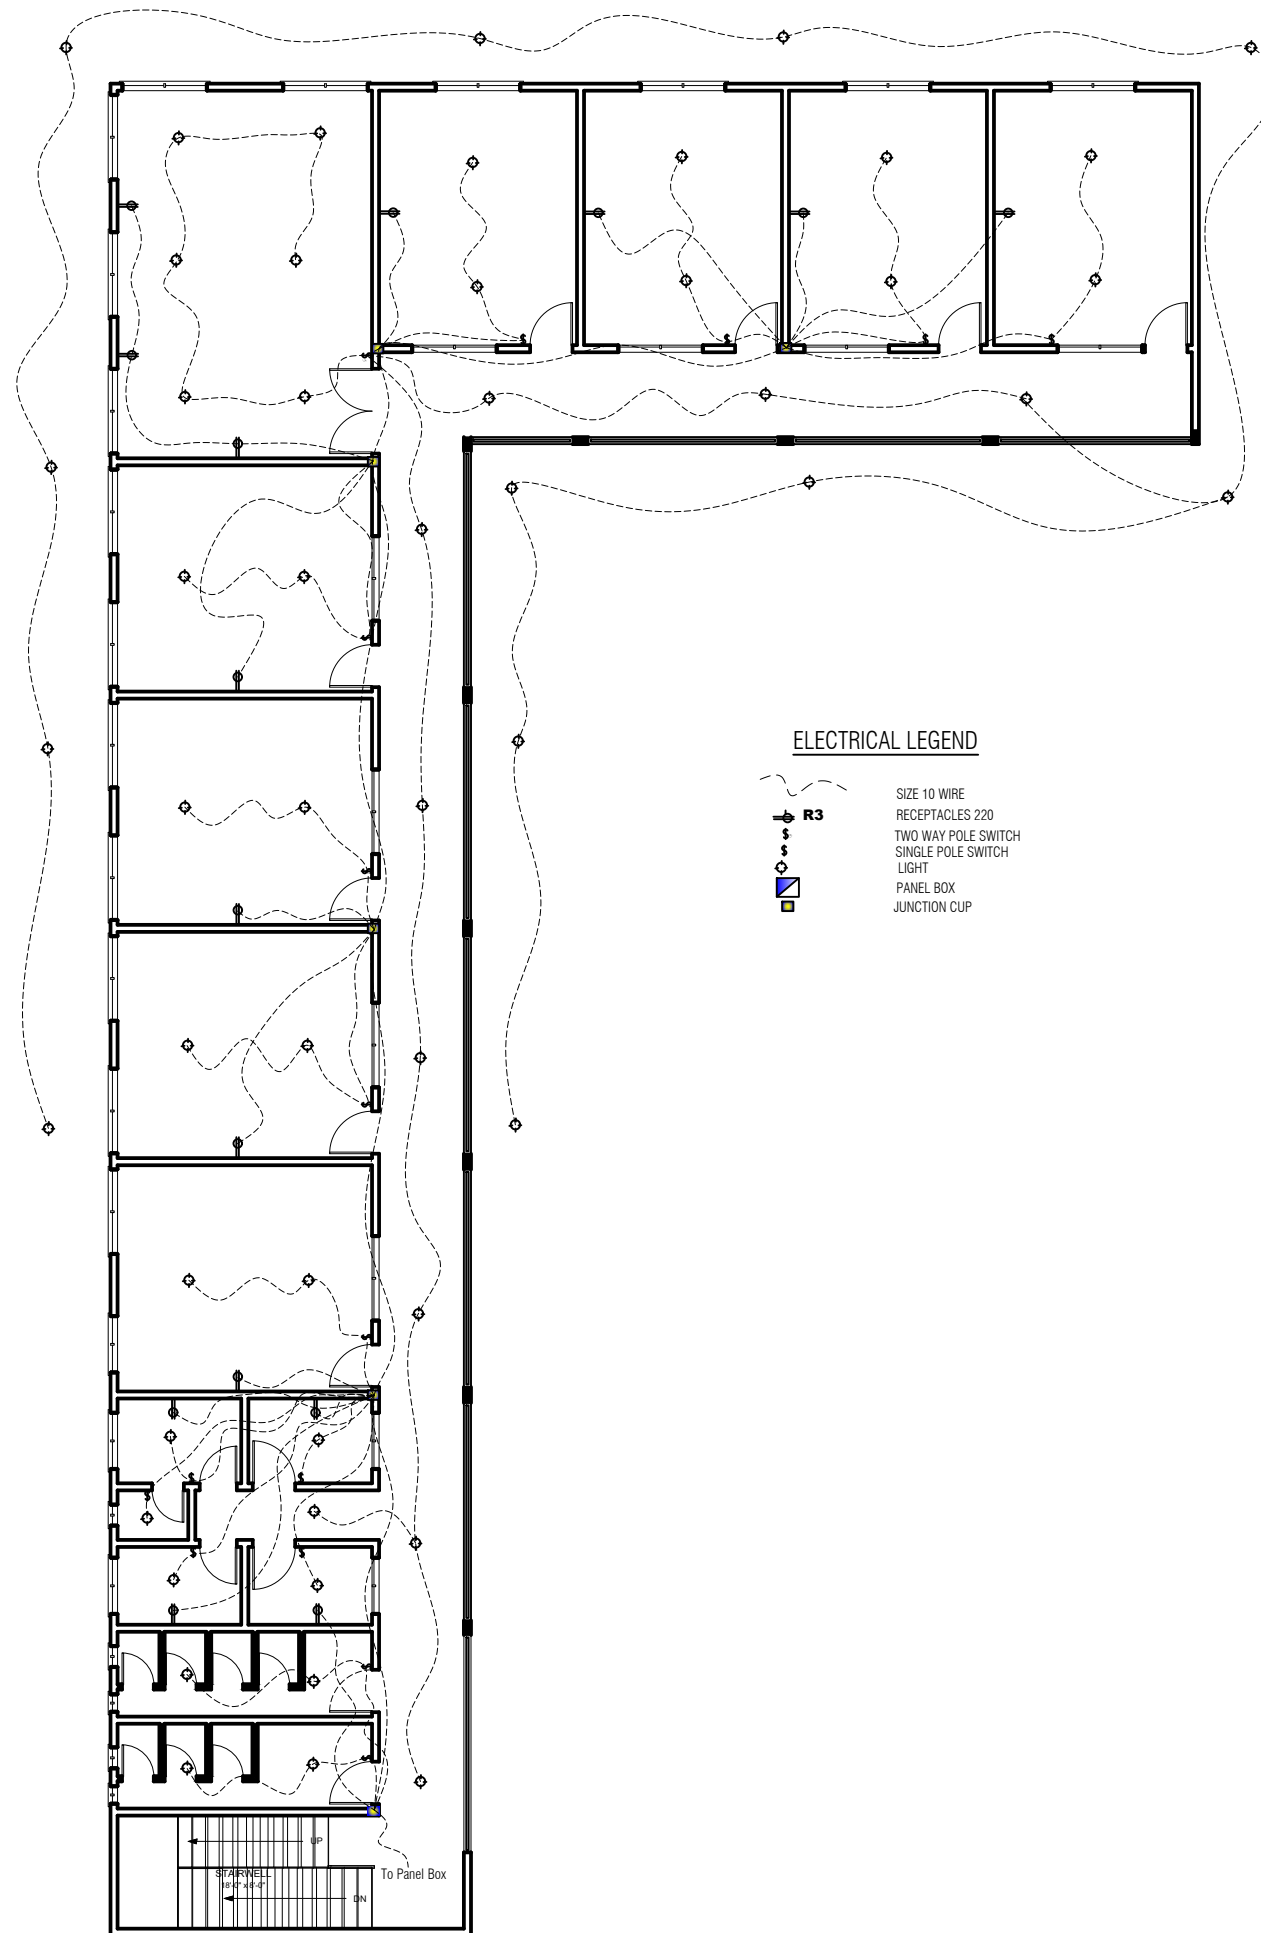

ELECTRICAL LEGEND



PROPOSE FIRST FLOOR ELECTRICAL PLAN




MOTTO:
QUALITY WITH PASSION

CLIENT :
HELP LIBERIA FOUNDATION
LOCATION : BUCHANAN CITY, LIBERIA
PROJECT :
PROPOSE: ELEMENTARY, JUNIOR & SENIOR HIGH SCHOOL




DRAWING TITLE:
PROPOSE FIRST FLOOR
ELECTRICAL PLAN

FUTURE BUILDER & DEVELOPMENT GROUP INC.		SIGN
DESIGNED BY :	Mr. Alexander P.B. Yeager Jr.	
DRAWING NO.	DATE	SCALE
A-220	OCTOBER 2020	1/8" = 1'-0"
Contact #: +231886232714/+231777544642		
Email: fbdgincorporated@gmail.com		

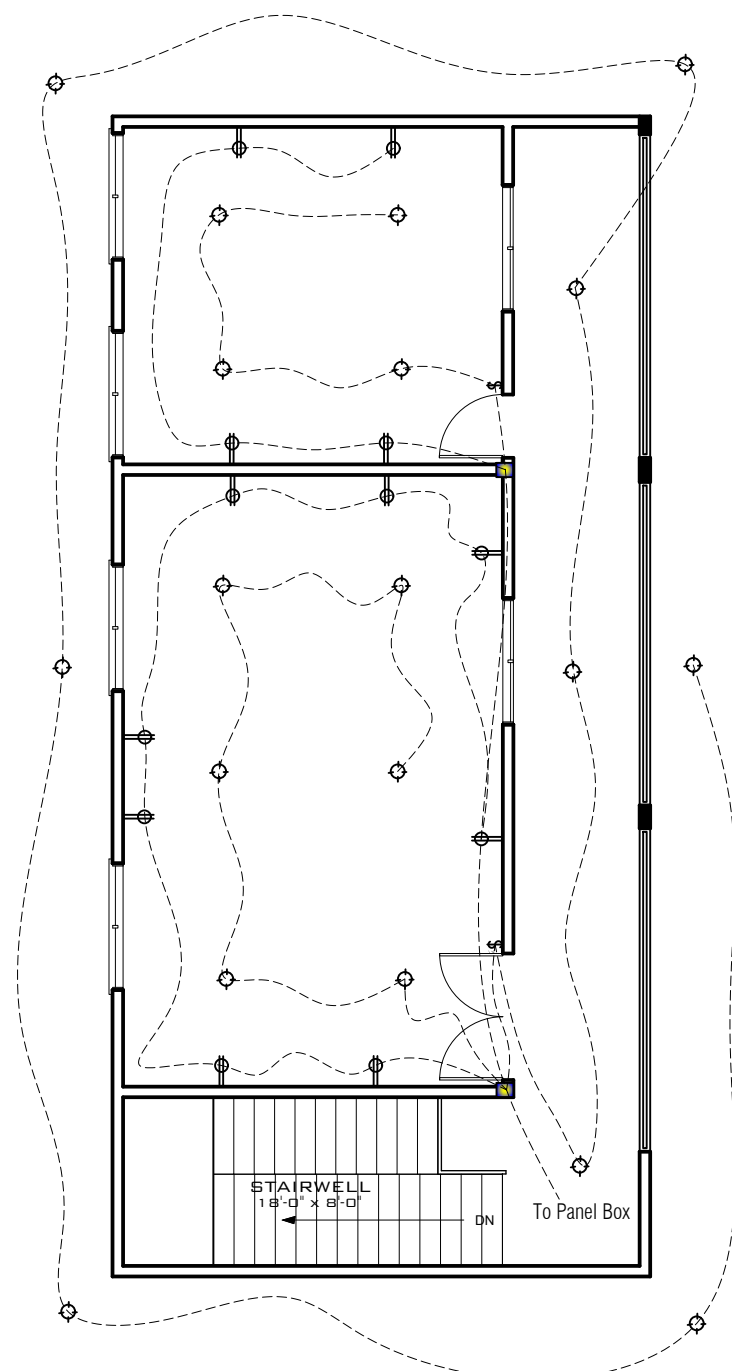 COPYRIGHT RESERVED
THIS DESIGN AND DETAIL ARE, AND
AT ALL TIMES THE EXCLUSIVE
PROPERTY OF HELP LIBERIA FOUNDATION
AND CAN NOT BE USED OR REPRODUCED
WITHOUT WRITTEN CONSENT.



ELECTRICAL LEGEND

	SIZE 10 WIRE
	RECEPTACLES 220
	TWO WAY POLE SWITCH
	SINGLE POLE SWITCH
	LIGHT
	PANEL BOX
	JUNCTION CUP

A PROPOSE LAST FLOOR ELECTRICAL PLAN









MOTTO:
QUALITY WITH PASSION

CLIENT :
HELP LIBERIA FOUNDATION
LOCATION : BUCHANAN CITY, LIBERIA
PROJECT :
PROPOSE: ELEMENTARY, JUNIOR & SENIOR HIGH SCHOOL

DRAWING TITLE :
PROPOSE LAST FLOOR ELECTRICAL PLAN

FUTURE BUILDER & DEVELOPMENT GROUP INC.		SIGN
DESIGNED BY :	Mr. Alexander P.B. Yeaher Jr.	
DRAWING NO.	DATE	SCALE
A-221	OCTOBER 2020	1/8" = 1'-0"
Contact #; +231886232714/+231777544642		
Email: fbdgincorporated@gmail.com		

COPYRIGHT RESERVED
THIS DESIGN AND DETAIL ARE, AND
AT ALL TIMES THE EXCLUSIVE
PROPERTY OF HELP LIBERIA FOUNDATION
AND CAN NOT BE USED OR REPRODUCED
WITHOUT WRITTEN CONSENT.

 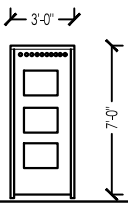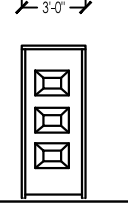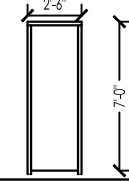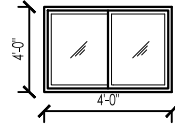 DIAGRAM PREVIEWS							
WIDTH X HEIGHT	3'-0 X 7'-0"	3'-0" X 7'-0"	2'-6" X 7'-0"		4'-0" X 6'-0"	4'-0" X 4'-0"	2'-0" X 2'-0"
DESCRIPTION	steel door	Hardwood panel door	plywood door		sliding glass window in aluminum frame	sliding gl win in alu frame	sliding glass window in aluminum frame
QUANTITY	1	32	15		56	6	10
FRAME FINISH	as manufactured	as manufactured	as manufactured		as manufactured	as manufactured	as manufactured
DOOR LEAF FINISH	as manufactured	as manufactured	as manufactured		as manufactured	as manufactured	as manufactured
IRON MONARY	as manufactured	lock cylinder with key hinges 2 pieces brass type	lock cylinder with key hinges 2 piecess brass type				
LOCATION	storage/store room	classrooms door, kitchen & bathrooms	toilet door & bathroom		classroom/auditorium/cafeteria/ vacation room/Library/Science Lab & teacher lunch	kitchen & offices	bath room



MOTTO:
QUALITY WITH PASSION

CLIENT :
HELP LIBERIA FOUNDATION
LOCATION : BUCHANAN CITY, LIBERIA
PROJECT :
PROPOSE: ELEMENTARY, JUNIOR & SENIOR HIGH SCHOOL

DRAWING TITLE :
DOORS & WINDOWS SCHEDULE

FUTURE BUILDER & DEVELOPMENT GROUP INC.		SIGN
DESIGNED BY :	Mr. Alexander P.B. Yeaher Jr.	
DRAWING NO.	DATE	SCALE
A-222	OCTOBER 2020	1/8" = 1'-0"

Contact #; +231886232714/+ 231777544642

Email: fbdgincorporated@gmail.com

COPYRIGHT RESERVED
THIS DESIGN AND DETAIL ARE, AND
AT ALL TIMES THE EXCLUSIVE
PROPERTY OF HELP LIBERIA FOUNDATION
AND CAN NOT BE USED OR REPRODUCED
WITHOUT WRITTEN CONSENT.

A

DOORS AND WINDOWS SCHEDULE